

NOTE: DIMENSIONS ON THESE DRAWINGS SHALL HAVE PRECEDENCE OVER SCALED DIMENSIONS. CONTRACTORS SHALL VERIFY AND BE RESPONSIBLE FOR ALL DIMENSIONS AND CONDITIONS ON THE JOB. THE DESIGNER MUST BE NOTIFIED IMMEDIATELY OF ANY VARIATIONS FROM THE DIMENSIONS AND CONDITIONS SHOWN BY THESE DRAWINGS.

NOTE: DISCREPANCY ON ALL DRAWINGS & SPECIFICATIONS (ARCHITECTURAL, STRUCTURAL, SANITARY, ELECTRICAL, MECHANICAL ETC.) SHALL BE SUBJECT FOR VERIFICATION.



BATAAN PENINSULA STATE UNIVERSITY
TECHNICAL WORKING GROUP FOR INFRASTRUCTURE
CAPITOL COMPOUND, BRGY. TENEJERO, CITY OF BALANGA, BATAAN,
E-MAIL: bpsu.twginfo2016@gmail.com/ bpsupes2017@gmail.com
TELEPHONE NO. : (047) 237-15-98

CEILING FINISH SCHEDULE (FOR ARCHITECT'S APPROVAL)

CF-1	4mm THK. FIBER CEMENT BOARD (SEMI GLOSS PAINTED FINISH)
CF-2	4mm THK. GYPSUM BOARD (SEMI GLOSS PAINTED FINISH)
CF-3	600 x 600 mm ACOUSTIC BOARD
CF-4	EXPOSED CEILING
CF-5	
CF-6	
CF-7	

SYMBOLS & LEGEND (FOR ARCHITECT'S APPROVAL)

	7 X 1W, 6500K DAY LIGHT, 920 lm, 220-240V/60Hz
	W/ LED DRIVER
	MIRRORIZED LIGHTING LUMINARES (T8 SURFACE MOUNTED W/ MAGNETIC BALLAST
	24' X 48', 4 x 40W
	7X1 WATTS DOWN LIGHT LED
	PINLIGHT CASING E-27 SOCKETS
	IN CEILING, 6.5" 2-WAY SPEAKER

SYMBOLS & LEGEND (FOR ARCHITECT'S APPROVAL)

	30" DECORATIVE CEILING PAN WITH 5 LIGHTS AND BLADES
	3W EMERGENCY LIGHT
	25 PATTERN RGB LED STAGE LIGHT
	WALL LAMP WITH 12W LED BULB

PROJECT TITLE:
**CONSTRUCTION OF UNIVERSITY
RESEARCH, EXTENSION AND
DEVELOPMENT INNOVATION
CENTER AT ABUCAY CAMPUS**

LOCATION:
BATAAN PENINSULA STATE UNIVERSITY (ABUCAY CAMPUS)
ABUCAY, BATAAN

STRUCTURAL ENGINEER
REG. NO. :
PTR. NO. :
PLACE :
TIN NO. :

MASTER PLUMBER/SANITARY ENGINEER
REG. NO. :
PTR. NO. :
PLACE :
TIN NO. :

PROFESSIONAL ELECTRICAL ENGINEER
REG. NO. :
PTR. NO. :
PLACE :
TIN NO. :

PROFESSIONAL MECHANICAL ENGINEER
REG. NO. :
PTR. NO. :
PLACE :
TIN NO. :

REVISION		
NO.	DESCRIPTION	DATE
1		
2		

PREPARED BY:

AR. ROXETTE S. UMEREZ
ARCHITECT 1, BPSU TWG

REG. NO. :
PTR. NO. :
PLACE :

CHECKED BY:

AR. JO-ANA MARI Z. TANEGA
ARCHITECT 1, PPES OFFICE

REG. NO. :
PTR. NO. :
PLACE :

REVIEWED BY:

ENGR. ALFREDO D. VALENTOS
DIRECTOR, PPES

RECOMMENDED BY:

DR. EDMUNDO C. TUNGOL
VICE PRESIDENT ADMIN. & FINANCE


APPROVED BY:

DR. GREGORIO J. RODIS
UNIVERSITY PRESIDENT

REPUBLIC ACT 9266.
NOTE: THIS DRAWING, AS AN INSTRUMENT OF SERVICE, IS THE PROPERTY OF : BATAAN PENINSULA STATE UNIVERSITY AND AS SUCH MUST NOT BE REPRODUCED OR COPIED IN PART OR IN WHOLE WITHOUT THEIR PERMISSION ALL DRAWINGS ARE TO BE RETURNED WHEN NO LONGER IN USE,

SHEET CONTENT:
• REFLECTED CEILING PLAN (GROUND FLOOR)

SHEET NUMBER:
A12

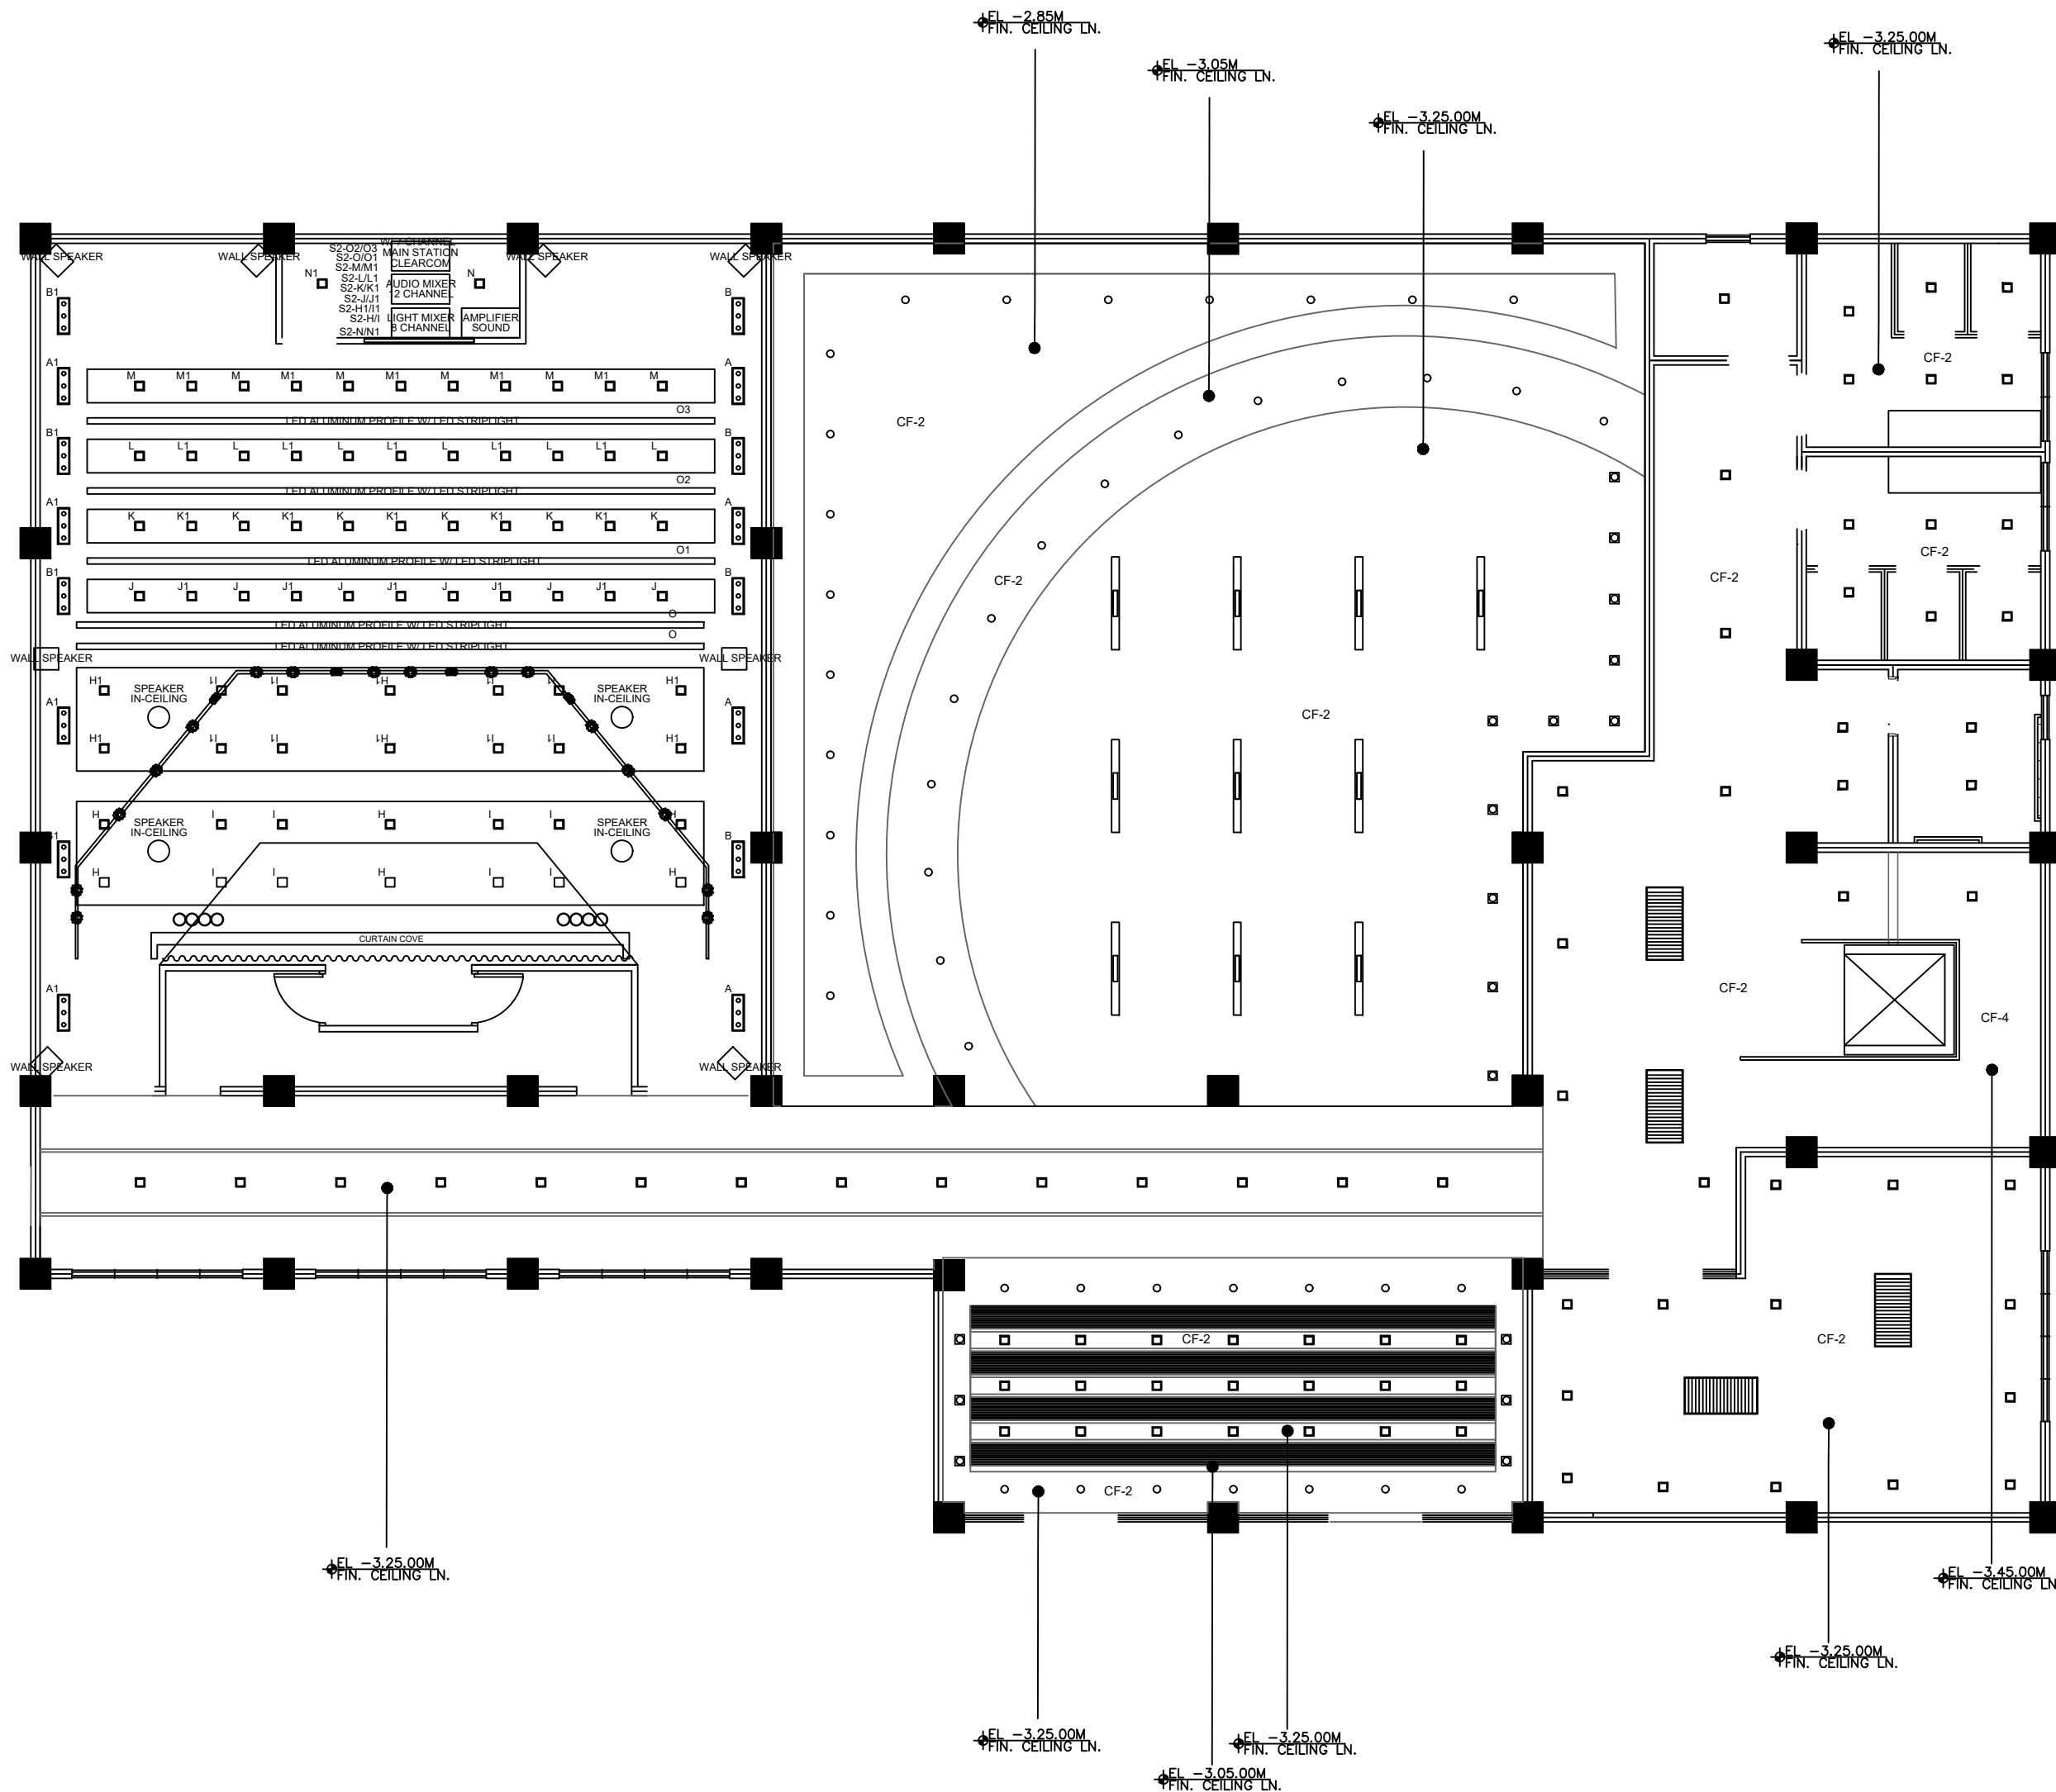

REFLECTED CEILING PLAN
1
A12
SCALE 1:100 MTS