


NOTE :
WRITTEN DIMENSIONS ON THESE DRAWINGS SHALL HAVE PRECEDENCE OVER SCALED DIMENSIONS.
DIMENSIONS CONTRACTORS SHALL VERIFY AND BE RESPONSIBLE FOR ALL DIMENSIONS.
ANY DISCREPANCY ON ALL DRAWINGS & SPECIFICATIONS SHALL BE THE RESPONSIBILITY OF THE CONTRACTOR.
ANY DISCREPANCY ON ALL DRAWINGS & SPECIFICATIONS SHALL BE THE RESPONSIBILITY OF THE CONTRACTOR.
ANY DISCREPANCY ON ALL DRAWINGS & SPECIFICATIONS SHALL BE THE RESPONSIBILITY OF THE CONTRACTOR.

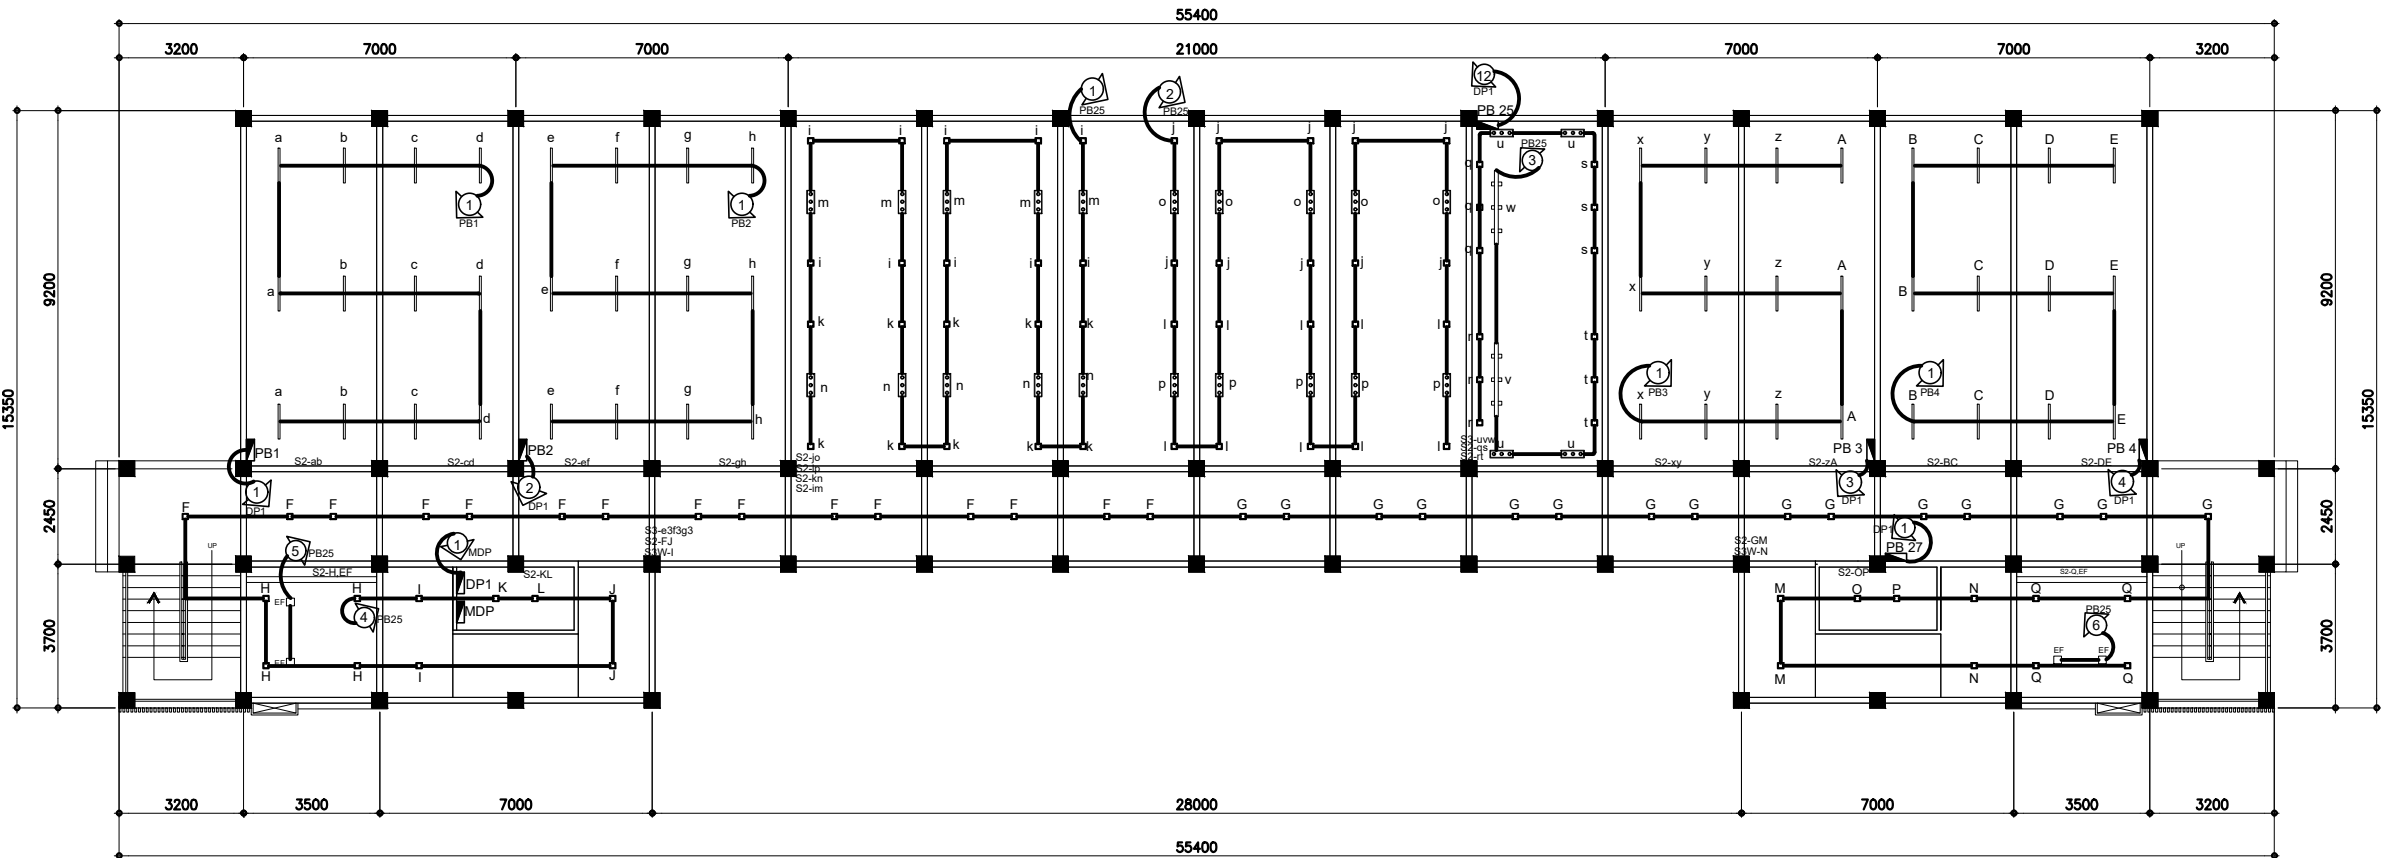

GROUND FLOOR LIGHTING LAYOUT
SCALE : 1:150 MTS.
C
E-DC-01 E-DC-01



BATAAN PENINSULA STATE UNIVERSITY
TECHNICAL WORKING GROUP FOR INFRASTRUCTURE
CAPITOL COMPOUND, BRGY. TENEJERO, CITY OF BALANGA, BATAAN
E-MAIL: bpsu.twginfra2016@gmail.com / bpsuppes2017@gmail.com
TELEPHONE NO.: (047) 237-15-98

LEGEND			
S1a	TUMBLER SWITCH, SINGLE POLE	□	PINLIGHT WITH LED BULB
S2ab	TUMBLER SWITCH, 2-GANG	—	SINGLE T8 LED LIGHTS
S3abc	TUMBLER SWITCH, 3-GANG	□EF	EXHAUST FAN
S3W-ab...	TUMBLER SWITCH, 3-WAY	—	TRACK LIGHTS
CO	DUPLEX CONVENIENCE OUTLET	□	PINLIGHTS WITH LED BULB
WFO	WALL FAN MOUNTED C.O.	○	WALL LIGHT
ELO	EMERGENCY LIGHT OUTLET	○	LAMP POST
WPO	WEATHERPROOF C.O.	●	BOLLARD LIGHTS
ACU	AIRCONDITIONING UNIT OUTLET	●	PANEL BOARD
①	CIRCUIT HOMERUN	■	

PROJECT TITLE
REPAIR & REHABILITATION OF ACADEMIC BLDG. II AT DINA-LUPIHAN CAMPUS

LOCATION
BATAAN PENINSULA STATE UNIVERSITY
(DINALUPHAN CAMPUS) DINALUPHAN, BATAAN

STRUCTURAL ENGINEER
REF. NO.
PTR. NO.
PLACE
TIN NO.

MASTER PLUMBER/SANITARY ENGINEER
REF. NO.
PTR. NO.
PLACE
TIN NO.

PROFESSIONAL ELECTRICAL ENGINEER
REF. NO.
PTR. NO.
PLACE
TIN NO.

PROFESSIONAL MECHANICAL ENGINEER
REF. NO.
PTR. NO.
PLACE
TIN NO.

REVISION
NO. DESCRIPTION DATE
1
2

PREPARED BY:
AR. ROXETTE S. UMEREZ
ARCHITECT 1, BPSU TWG

MR. BILLY ALIPIO
CAMPUS DIRECTOR

ENGR. ALFREDO D. VALENTOS
DIRECTOR OF PPES

DR. EDMUNDO C. TUNGOL
VICE PRESIDENT ADMIN. & FINANCE

DR. GREGORIO J. RODIS
UNIVERSITY PRESIDENT

REPUBLIC ACT 9266
NOTE: THIS DRAWING, AS AN INSTRUMENT OF SERVICE IS THE PROPERTY OF : BATAAN PENINSULA STATE UNIVERSITY AND AS SUCH MUST NOT BE REPRODUCED OR COPIED IN PART OR IN WHOLE WITHOUT THEIR PERMISSION ALL DRAWINGS ARE TO BE RETURNED WHEN NO LONGER IN USE.

SHEET CONTENT: SHEET NUMBER
GROUND FLOOR LIGHTING LAYOUT
LEGEND
E-DC-01