

NOTE : WRITTEN DIMENSIONS ON THESE DRAWINGS SHALL HAVE PRECEDENCE OVER SCALED DIMENSIONS. CONTRACTORS SHALL VERIFY AND BE RESPONSIBLE FOR ALL DIMENSIONS & SPECIFICATIONS AND CONDITIONS ON THE JOB. THE DESIGNER MUST BE NOTIFIED IMMEDIATELY OF ANY VARIATIONS FROM THE DIMENSIONS AND CONDITIONS SHOWN BY THESE DRAWINGS.

NOTE : DISCREPANCY ON ALL DRAWINGS & SPECIFICATIONS (ARCHITECTURAL, STRUCTURAL, SANITARY, ELECTRICAL, MECHANICAL ETC.) SHALL BE SUBJECT FOR VERIFICATION. DO NOT SCALE!



BATAAN PENINSULA STATE UNIVERSITY
TECHNICAL WORKING GROUP FOR INFRASTRUCTURE

CAPITOL COMPOUND, BROY, TENEJERO, CITY OF BALANGA, BATAAN,
E-MAIL: bpsu.tenjero2016@gmail.com / bpsuugp2017@gmail.com
TELEPHONE NO. : (047) 237-15-98

FLOOR FINISH SCHEDULE (FOR ARCHITECT'S APPROVAL)



FF-1	1.5mm X 150mm x 900mm VINYL TILES
FF-2	SMOOTH PLAIN CEMENT FINISH
FF-3	6mm X 300mm x 600mm CERAMIC VITRIFIED TILES (NON-SKID)
FF-4	PLAIN CEMENT (ROUGH FINISH) (FOR TOILET FACILITIES)

WALL FINISH SCHEDULE (FOR ARCHITECT'S APPROVAL)

W-1	SMOOTH PAINTED FINISH

CEILING FINISH SCHEDULE (FOR ARCHITECT'S APPROVAL)

CF-1	4mm x 1200mm x 2400mm FIBER CEMENT BOARD

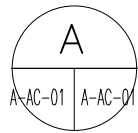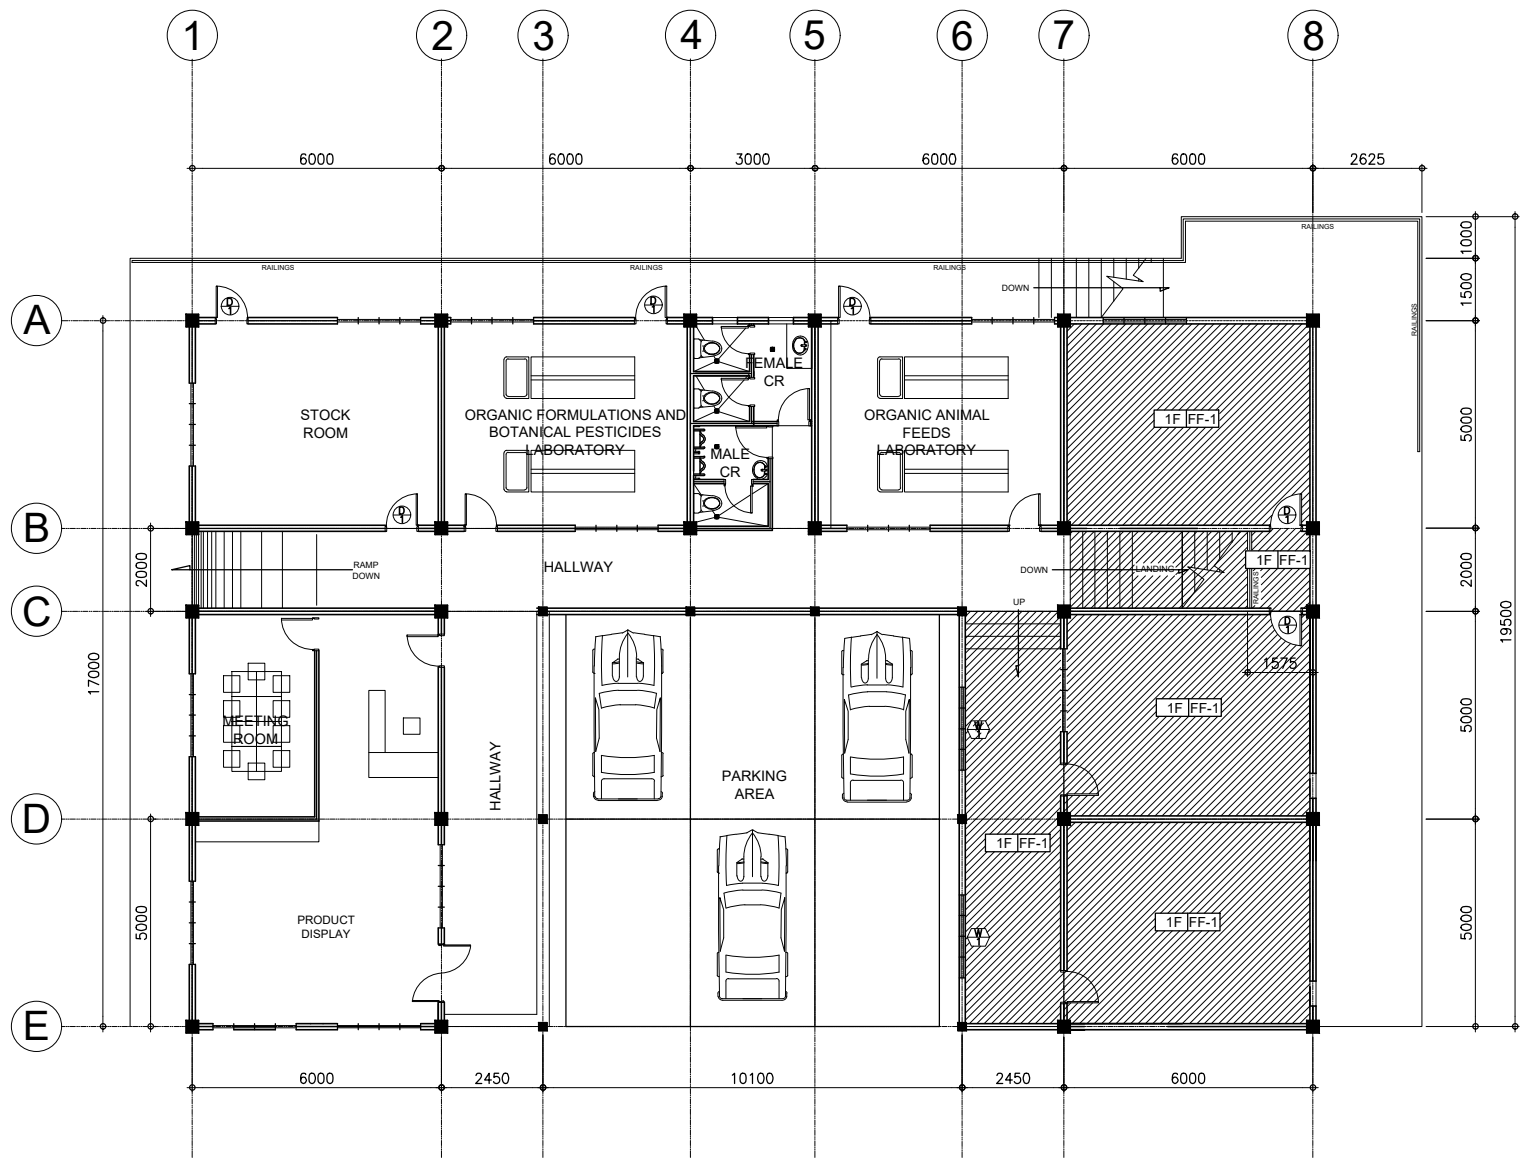

GROUND FLOOR PLAN

SCALE : 1:100 MTS.

PROJECT TITLE

COMPLETION OF ORGANIC
AGRICULTURE RESEARCH AND
DEVELOPMENT FACILITY

LOCATION:

BATAAN PENINSULA STATE UNIVERSITY (ABUCAY CAMPUS)
ABUCAY, BATAAN

STRUCTURAL ENGINEER

REG. NO. :
PTR. NO. :
PLACE :
TIN NO. :

MASTER PLUMBER/SANITARY ENGINEER

REG. NO. :
PTR. NO. :
PLACE :
TIN NO. :

PROFESSIONAL ELECTRICAL ENGINEER

REG. NO. :
PTR. NO. :
PLACE :
TIN NO. :

PROFESSIONAL MECHANICAL ENGINEER

REG. NO. :
PTR. NO. :
PLACE :
TIN NO. :

REVISION

NO.	DESCRIPTION	DATE
1		
2		

PREPARED BY:

AR. ROXETTE S. UMEREZ

ARCHITECT 1, BPSU TWG

REG. NO. :
PTR. NO. :
PLACE :
TIN NO. :

REVIEWED BY:

AR. RENIEL M. MAUSISA

ARCHITECT 1, BPSU TWG

NOTED BY:

ENGR. ALFREDO D. VALENTOS

DIRECTOR OF PPES

RECOMMENDED BY:

DR. EDMUNDO C. TUNGOL

VICE PRESIDENT ADMIN. & FINANCE

APPROVED BY:

DR. GREGORIO J. RODIS

UNIVERSITY PRESIDENT

REPUBLIC ACT 9266.

NOTE: THIS DRAWING, AS AN INSTRUMENT OF SERVICE
IS THE PROPERTY OF : BATAAN PENINSULA STATE
UNIVERSITY AND AS SUCH MUST NOT BE
REPRODUCED OR COPIED IN PART OR IN WHOLE
WITHOUT THEIR PERMISSION ALL DRAWINGS ARE
TO BE RETURNED WHEN NO LONGER IN USE.

SHEET CONTENT:


GROUND FLOOR PLAN

SHEET NUMBER

A-AC-01

NOTE : WRITTEN DIMENSIONS ON THESE DRAWINGS SHALL HAVE PRECEDENCE OVER SCALED DIMENSIONS. CONTRACTORS SHALL VERIFY AND BE RESPONSIBLE FOR ALL DIMENSIONS AND CONDITIONS ON THE JOB. THE DESIGNER MUST BE NOTIFIED IMMEDIATELY OF ANY VARIATIONS FROM THE DIMENSIONS AND CONDITIONS SHOWN BY THESE DRAWINGS.


NOTE : DISCREPANCY ON ALL DRAWINGS & SPECIFICATIONS (ARCHITECTURAL, STRUCTURAL, SANITARY, ELECTRICAL, MECHANICAL ETC.) SHALL BE SUBJECT FOR VERIFICATION DO NOT SCALE!

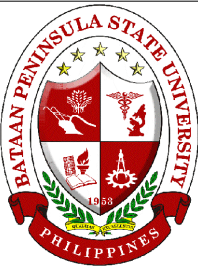

BATAAN PENINSULA STATE UNIVERSITY
TECHNICAL WORKING GROUP FOR INFRASTRUCTURE

CAPITOL COMPOUND, BROY, TENEJERO, CITY OF BALANGA, BATAAN,
E-MAIL: bpsu.tenjero2016@gmail.com / bpsuugres2017@gmail.com
TELEPHONE NO. : (047) 237-15-98

FLOOR FINISH SCHEDULE (FOR ARCHITECT'S APPROVAL)			WALL FINISH SCHEDULE (FOR ARCHITECT'S APPROVAL)			CEILING FINISH SCHEDULE (FOR ARCHITECT'S APPROVAL)		
FF-1	1.5mm X 150mm x 900mm VINYL TILES		W-1	SMOOTH PAINTED FINISH		CF-1	4mm x 1200mm x 2400mm FIBER CEMENT BOARD	
FF-2	SMOOTH PLAIN CEMENT FINISH							
FF-3	6mm X 300mm x 600mm CERAMIC VITRIFIED TILES (NON-SKID)							
FF-4	PLAIN CEMENT (ROUGH FINISH) (FOR TOILET FACILITIES)							

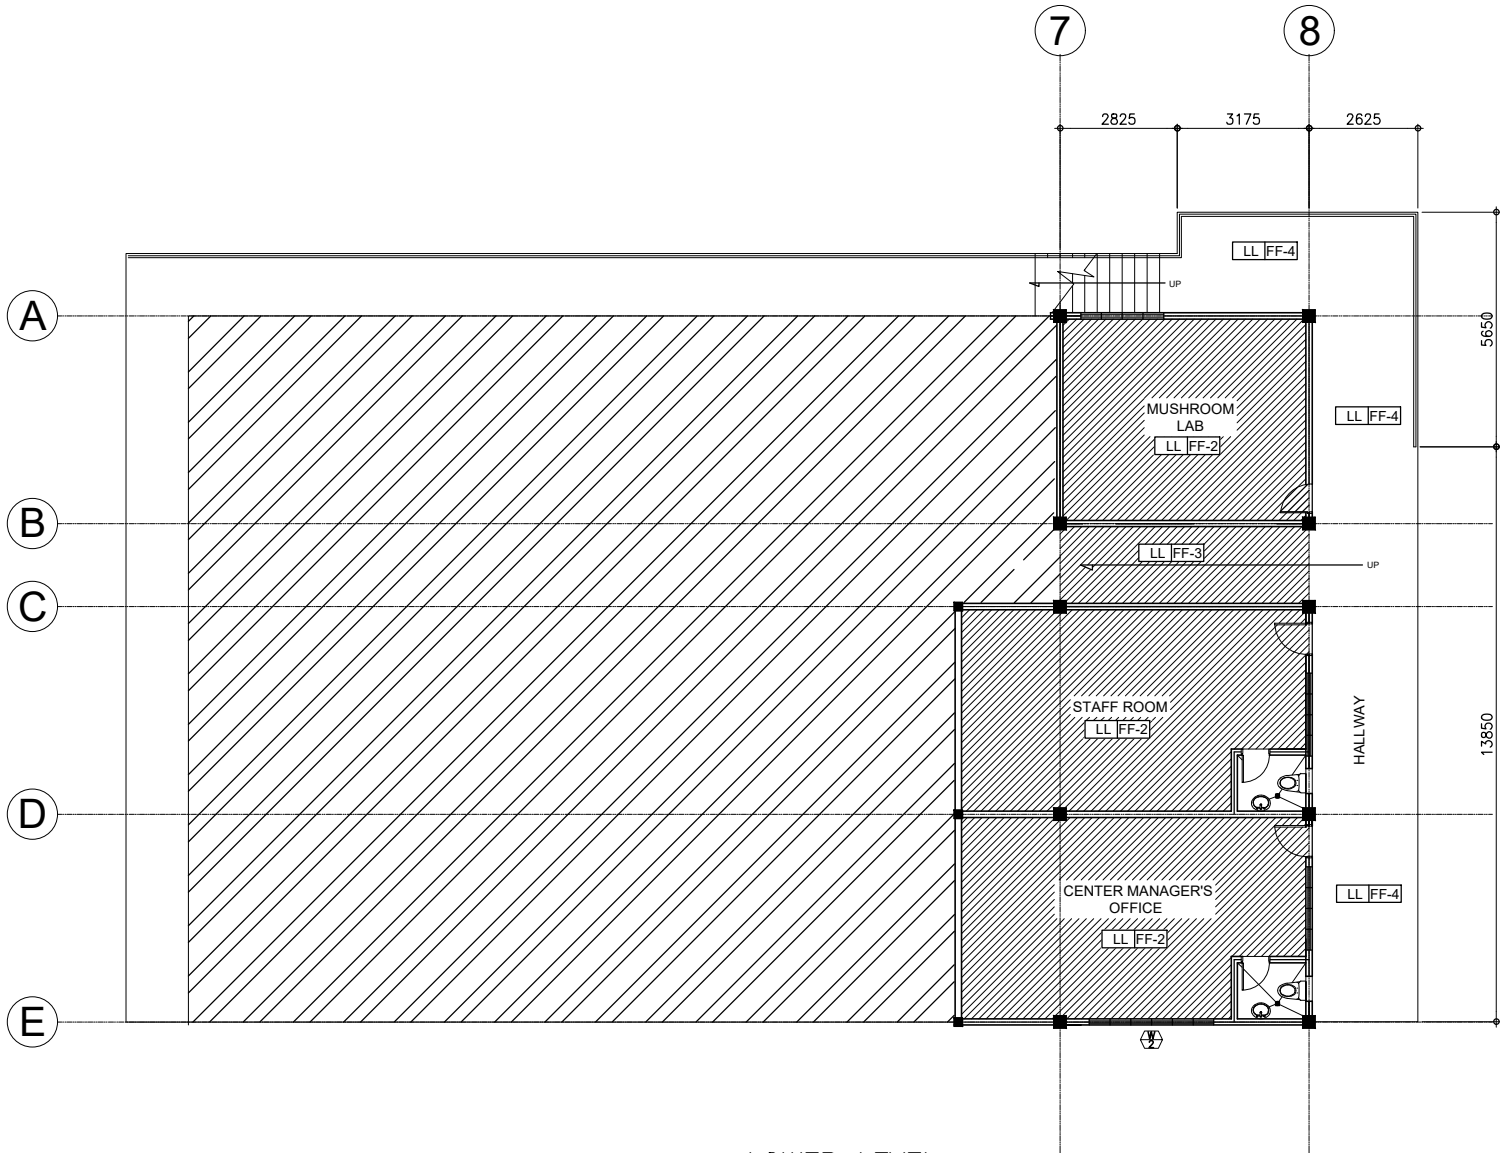

LOWER LEVEL FLOOR PLAN
SCALE : 1:100 MTS.

PROJECT TITLE

COMPLETION OF ORGANIC AGRICULTURE RESEARCH AND DEVELOPMENT FACILITY

LOCATION:

BATAAN PENINSULA STATE UNIVERSITY (ABUCAY CAMPUS) ABUCAY, BATAAN

STRUCTURAL ENGINEER

REG. NO. :
PTR. NO. :
PLACE :
TN NO. :

MASTER PLUMBER/SANITARY ENGINEER

REG. NO. :
PTR. NO. :
PLACE :
TN NO. :

PROFESSIONAL ELECTRICAL ENGINEER

REG. NO. :
PTR. NO. :
PLACE :
TN NO. :

PROFESSIONAL MECHANICAL ENGINEER

REG. NO. :
PTR. NO. :
PLACE :
TN NO. :

REVISION

NO.	DESCRIPTION	DATE
1		
2		

PREPARED BY:

AR. ROXETTE S. UMEREZ
ARCHITECT 1, BPSU TWG

REG. NO. :
PTR. NO. :
PLACE :
TN NO. :

REVIEWED BY:

AR. RENIEL M. MAUSISA
ARCHITECT 1, BPSU TWG

REG. NO. :
PTR. NO. :
PLACE :
TN NO. :

NOTED BY:

ENGR. ALFREDO D. VALENTOS
DIRECTOR OF PPES

RECOMMENDED BY:

DR. EDMUNDO C. TUNGOL
VICE PRESIDENT ADMIN. & FINANCE

APPROVED BY:

DR. GREGORIO J. RODIS
UNIVERSITY PRESIDENT

REPUBLIC ACT 9266.

NOTE: THIS DRAWING, AS AN INSTRUMENT OF SERVICE IS THE PROPERTY OF : BATAAN PENINSULA STATE UNIVERSITY AND AS SUCH MUST NOT BE REPRODUCED OR COPIED IN PART OR IN WHOLE WITHOUT THEIR PERMISSION ALL DRAWINGS ARE TO BE RETURNED WHEN NO LONGER IN USE.

SHEET CONTENT:


LOWER LEVEL FLOOR PLAN

SHEET NUMBER:

A-AC-02

NOTE : WRITTEN DIMENSIONS ON THESE DRAWINGS SHALL HAVE PRECEDENCE OVER SCALED DIMENSIONS. CONTRACTORS SHALL VERIFY AND BE RESPONSIBLE FOR ALL DIMENSIONS. ANY DISCREPANCY ON ALL DRAWINGS & SPECIFICATIONS SHALL BE THE RESPONSIBILITY OF THE CONTRACTOR. ANY DISCREPANCY IN MECHANICAL, ELECTRICAL, ETC., SHALL BE SUBJECT FOR VERIFICATION FROM THE DIMENSIONS AND CONDITIONS SHOWN BY THESE DRAWINGS.

NOTE : IF IN DOUBT, ASK DO NOT SCALE!

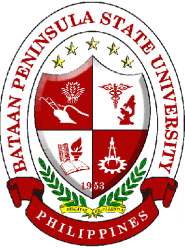

BATAAN PENINSULA STATE UNIVERSITY
TECHNICAL WORKING GROUP FOR INFRASTRUCTURE

CAPITAL COMPOUND, BRGY. TENGUERO, CITY OF BALANGA, BATAAN.
E-MAIL: bpsu.twg@bataan.gov.ph / bpsu@bataan.gov.ph
TELEPHONE NO. : (047) 237-15-98

FLOOR FINISH SCHEDULE (FOR ARCHITECT'S APPROVAL)


FF-1	1.5mm X 150mm x 900mm VINYL TILES
FF-2	SMOOTH PLAIN CEMENT FINISH
FF-3	6mm X 300mm x 600mm CERAMIC VITRIFIED TILES (NON-SKID)
FF-4	PLAIN CEMENT (ROUGH FINISH) (FOR TOILET FACILITIES)

WALL FINISH SCHEDULE (FOR ARCHITECT'S APPROVAL)

W-1	SMOOTH PAINTED FINISH
-----	-----------------------


CEILING FINISH SCHEDULE (FOR ARCHITECT'S APPROVAL)

CF-1	4mm x 1200mm x 2400mm FIBER CEMENT BOARD
------	--

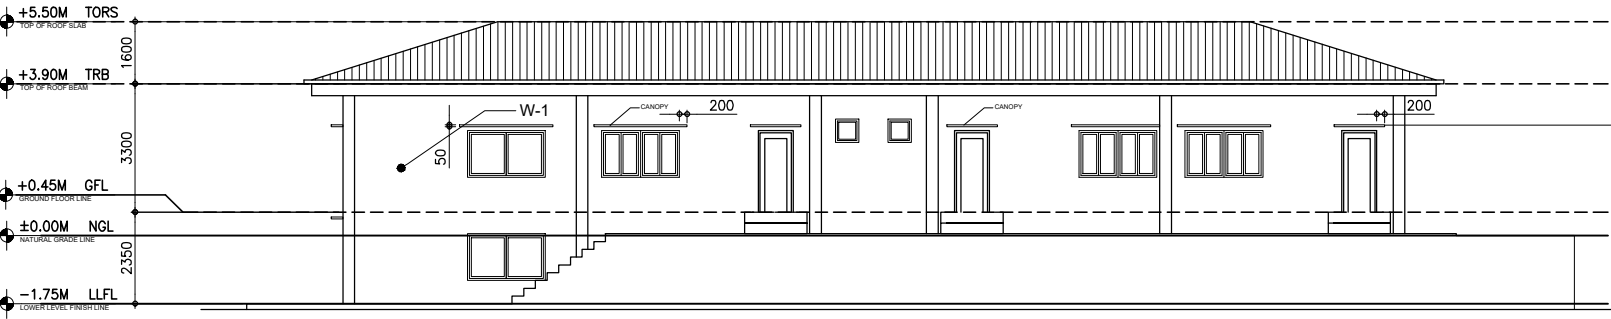

A REAR ELEVATION

SCALE : 1:100 MTS.

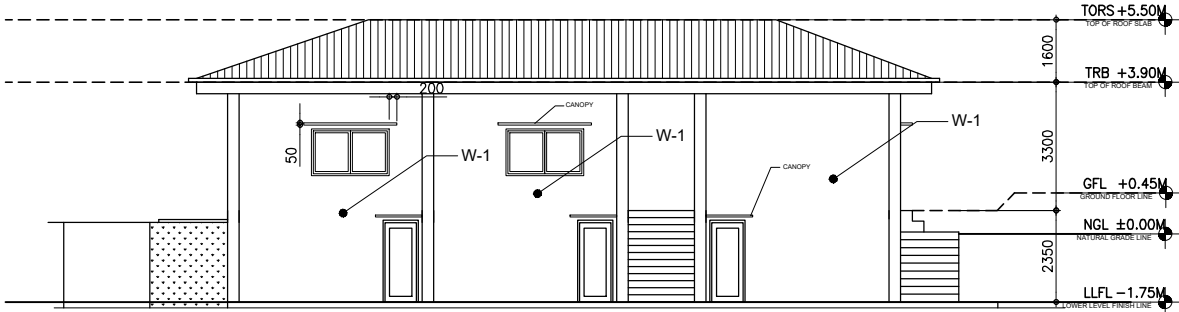

B RIGHT SIDE ELEVATION

SCALE : 1:100 MTS.

PROJECT TITLE:

COMPLETION OF ORGANIC
AGRICULTURE RESEARCH AND
DEVELOPMENT FACILITY

LOCATION:
BATAAN PENINSULA STATE UNIVERSITY (ABUCAY CAMPUS)
ABUCAY, BATAAN

STRUCTURAL ENGINEER
REG. NO. :
PTR. NO. :
PLACE :
TN. NO. :

MASTER PLUMBER/SANITARY ENGINEER
REG. NO. :
PTR. NO. :
PLACE :
TN. NO. :

PROFESSIONAL ELECTRICAL ENGINEER
REG. NO. :
PTR. NO. :
PLACE :
TN. NO. :

PROFESSIONAL MECHANICAL ENGINEER
REG. NO. :
PTR. NO. :
PLACE :
TN. NO. :

REVISION		
NO.	DESCRIPTION	DATE
1		
2		

PREPARED BY:

AR. ROXETTE S. UMEREZ
ARCHITECT 1, BPSU TWG

REG. NO. :
PTR. NO. :
PLACE :
TN. NO. :

REVIEWED BY:

AR. RENIEL M. MAUSISA
ARCHITECT 1, BPSU TWG

NOTED BY:

ENGR. ALFREDO D. VALENTOS
DIRECTOR OF PPES

RECOMMENDED BY:


DR. EDMUNDO C. TUNGOL
VICE PRESIDENT ADMIN. & FINANCE

APPROVED BY:


DR. GREGORIO J. RODIS
UNIVERSITY PRESIDENT

REPUBLIC ACT 9266.
NOTE: THIS DRAWING, AS AN INSTRUMENT OF SERVICE
IS THE PROPERTY OF : BATAAN PENINSULA STATE
UNIVERSITY AND AS SUCH MUST NOT BE
REPRODUCED OR COPIED IN PART OR IN WHOLE
WITHOUT THEIR PERMISSION ALL DRAWINGS ARE
TO BE RETURNED WHEN NO LONGER IN USE.


SHEET CONTENT:	SHEET NUMBER:
REAR ELEVATION RIGHT SIDE ELEVATION	A-AC-03

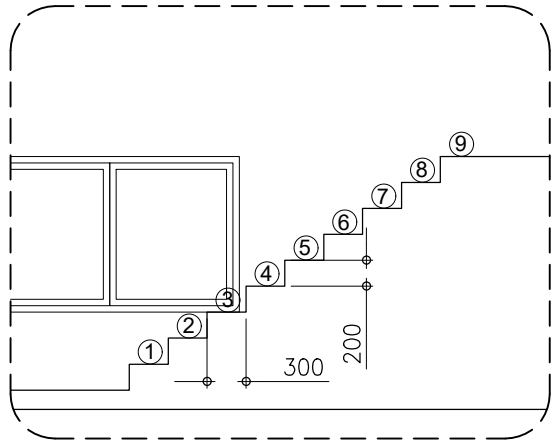

A STAIRS ELEVATION
A-AC-04 A-AC-04 SCALE : NTS.

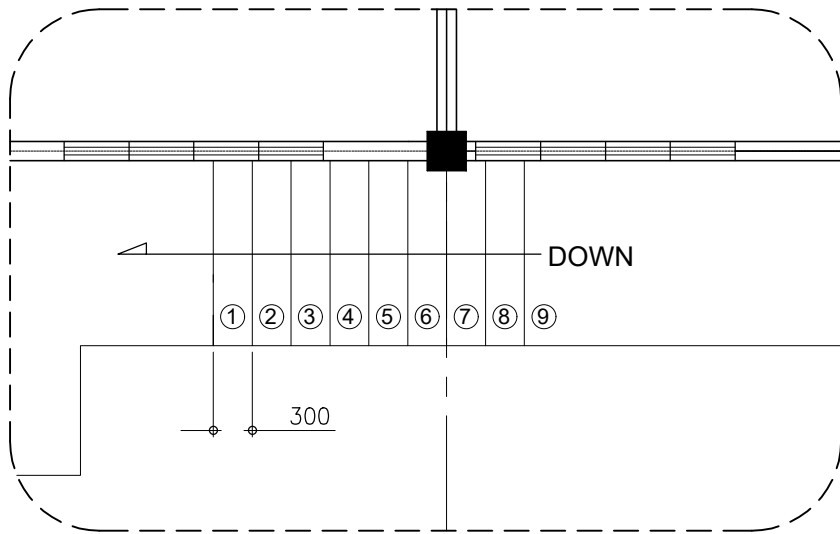

B STAIRS PLAN
A-AC-04 A-AC-04 SCALE : 1:100 NTS.

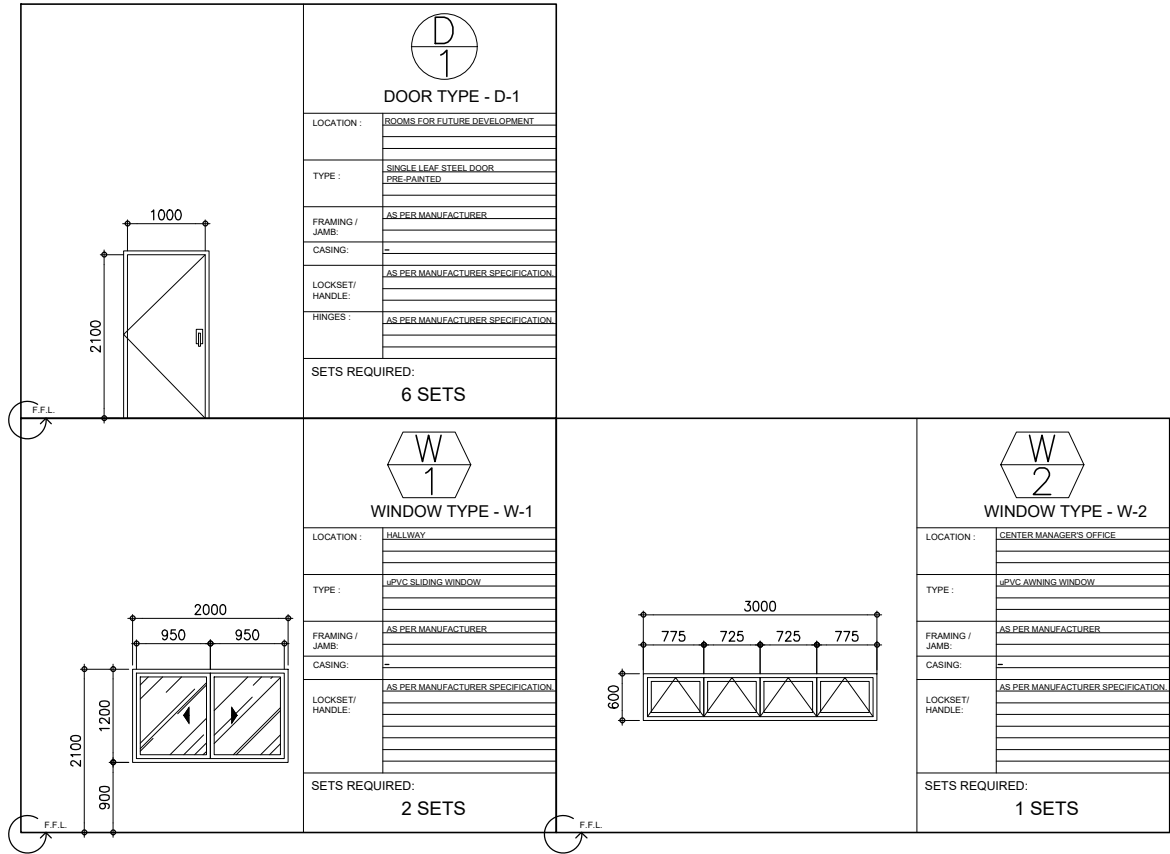

C SCHEDULE OF DOORS AND WINDOWS
A-AC-04 A-AC-04 SCALE : 1:50 MTS.

PROJECT TITLE:
COMPLETION OF ORGANIC
AGRICULTURE RESEARCH AND
DEVELOPMENT FACILITY

LOCATION:
BATAAN PENINSULA STATE UNIVERSITY (ABUCAY CAMPUS)
ABUCAY, BATAAN

STRUCTURAL ENGINEER
REG. NO :
PTR. NO :
PLACE :
TN. NO :

MASTER PLUMBER/SANITARY ENGINEER
REG. NO :
PTR. NO :
PLACE :
TN. NO :

PROFESSIONAL ELECTRICAL ENGINEER
REG. NO :
PTR. NO :
PLACE :
TN. NO :

PROFESSIONAL MECHANICAL ENGINEER
REG. NO :
PTR. NO :
PLACE :
TN. NO :

REVISION		
NO.	DESCRIPTION	DATE
1		
2		

PREPARED BY:
AR. ROXETTE S. UMEREZ
ARCHITECT 1, BPSU TWG

REVIEWED BY:
AR. RENIEL M. MAUSISA
ARCHITECT 1, BPSU TWG

NOTED BY:
ENGR. ALFREDO D. VALENTOS
DIRECTOR OF PPES


RECOMMENDED BY:
DR. EDMUNDO C. TUNGOL
VICE PRESIDENT ADMIN. & FINANCE

APPROVED BY:
DR. GREGORIO J. RODIS
UNIVERSITY PRESIDENT

REPUBLIC ACT 9266.
NOTE: THIS DRAWING, AS AN INSTRUMENT OF SERVICE
IS THE PROPERTY OF : BATAAN PENINSULA STATE
UNIVERSITY AND AS SUCH MUST NOT BE
REPRODUCED OR COPIED IN PART OR IN WHOLE
WITHOUT THEIR PERMISSION ALL DRAWINGS ARE
TO BE RETURNED WHEN NO LONGER IN USE.

SHEET CONTENT: STAIRS DETAIL
SCHEDULE OF DOORS AND
WINDOWS

SHEET NUMBER:
A-AC-04

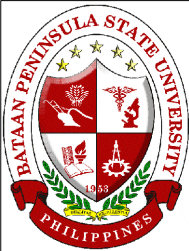

BATAAN PENINSULA STATE UNIVERSITY
TECHNICAL WORKING GROUP FOR INFRASTRUCTURE
CAPITAL COMPOUND, BRGY. TENILERO, CITY OF BALANGA, BATAAN
E-MAIL: bpsu.twg@bpsu.edu.ph / bpsu.twg@bpsu.edu.ph
TELEPHONE NO. : (047) 237-15-98

FLOOR FINISH SCHEDULE (FOR ARCHITECT'S APPROVAL)

FF-1	1.5mm X 150mm x 900mm VINYL TILES
FF-2	SMOOTH PLAIN CEMENT FINISH
FF-3	6mm X 300mm x 600mm CERAMIC VITRIFIED TILES (NON-SKID)
FF-4	PLAIN CEMENT (ROUGH FINISH) (FOR TOILET FACILITIES)

WALL FINISH SCHEDULE (FOR ARCHITECT'S APPROVAL)


W-1	SMOOTH PAINTED FINISH
-----	-----------------------

CEILING FINISH SCHEDULE (FOR ARCHITECT'S APPROVAL)

CF-1	4mm x 1200mm x 2400mm FIBER CEMENT BOARD
------	--

NOTE : WRITTEN DIMENSIONS ON THESE DRAWINGS SHALL HAVE PRECEDENCE OVER SCALED DIMENSIONS. CONTRACTORS SHALL VERIFY AND BE RESPONSIBLE FOR ALL DIMENSIONS SHOWN ON THESE DRAWINGS. ANY DISCREPANCY ON ALL DRAWINGS & SPECIFICATIONS SHALL BE THE RESPONSIBILITY OF THE CONTRACTOR. ANY VARIATIONS FROM THE DIMENSIONS AND CONDITIONS SHOWN BY THESE DRAWINGS SHALL BE SUBJECT FOR VERIFICATION AND APPROVAL BY THE ENGINEER.


NOTE : IF IN DOUBT, ASK DO NOT SCALE!

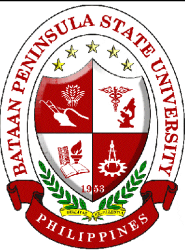

BATAAN PENINSULA STATE UNIVERSITY
TECHNICAL WORKING GROUP FOR INFRASTRUCTURE

CAPITAL COMPOUND, BRGY. TENILERO, CITY OF BALANGA, BATAAN
E-MAIL: bpsu.twg@bpsu.edu.ph / bpsu.twg@bpsu.edu.ph
TELEPHONE NO. : (047) 237-15-98

LEGENDS AND SYMBOLS					
	6w, PINLIGHT ROUND RECESSED TYPE, MR16 SOCKET				
	LED LINEAR LIGHT (1200mm x 50mm) RECESSED TYPE				
	HOMERUN				
	CONVENIENCE OUTLET				

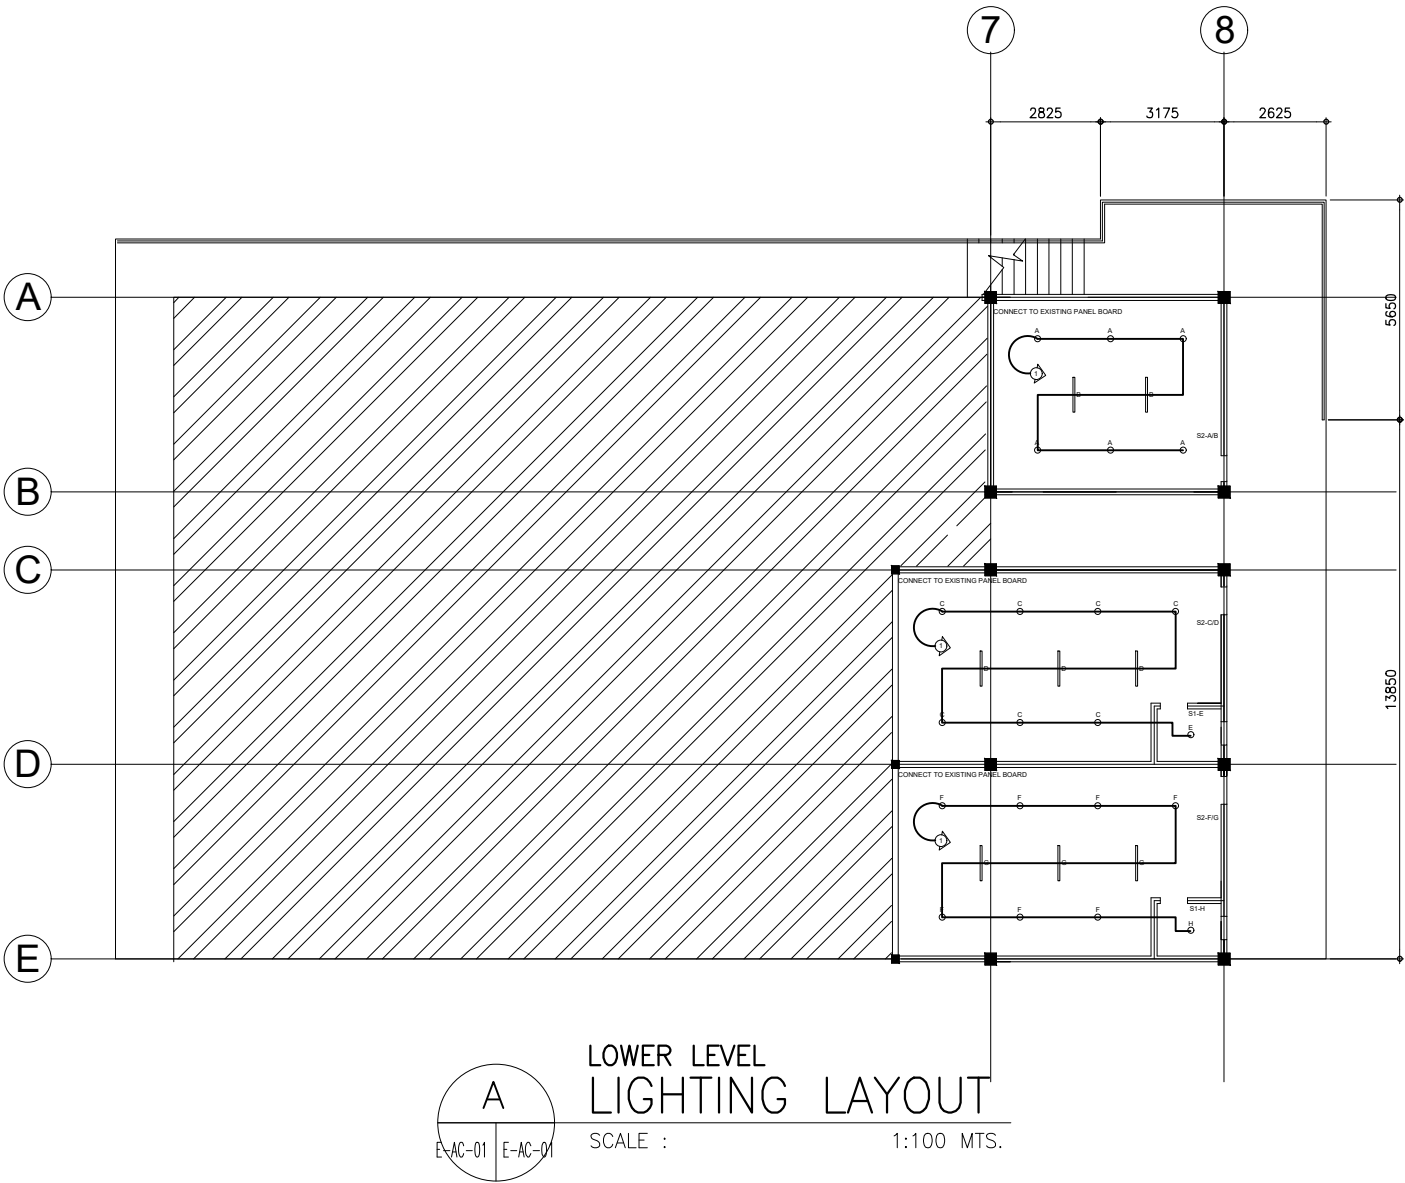


LOWER LEVEL LIGHTING LAYOUT
SCALE : 1:100 MTS.

PROJECT TITLE:		
COMPLETION OF ORGANIC AGRICULTURE RESEARCH AND DEVELOPMENT FACILITY		
LOCATION:		
BATAAN PENINSULA STATE UNIVERSITY (ABUCAY CAMPUS), ABUCAY, BATAAN		
STRUCTURAL ENGINEER		
REG. NO. :		
PTR. NO. :		
PLACE :		
TIN. NO. :		
MASTER PLUMBER/SANITARY ENGINEER		
REG. NO. :		
PTR. NO. :		
PLACE :		
TIN. NO. :		
PROFESSIONAL ELECTRICAL ENGINEER		
REG. NO. :		
PTR. NO. :		
PLACE :		
TIN. NO. :		
PROFESSIONAL MECHANICAL ENGINEER		
REG. NO. :		
PTR. NO. :		
PLACE :		
TIN. NO. :		
REVISION		
NO.	DESCRIPTION	DATE
1		
2		
PREPARED BY:		
AR. ROXETTE S. UMEREZ		
ARCHITECT 1, BPSU TWG		
REG. NO. :		
PTR. NO. :		
PLACE :		
TIN. NO. :		
REVIEWED BY:		
AR. RENIEL M. MAUSISA		
ARCHITECT 1, BPSU TWG		
NOTED BY:		
ENGR. ALFREDO D. VALENTOS		
DIRECTOR OF PPES		
RECOMMENDED BY:		
DR. EDMUNDO C. TUNGOL		
VICE PRESIDENT ADMIN. & FINANCE		
APPROVED BY:		
DR. GREGORIO J. RODIS		
UNIVERSITY PRESIDENT		
REPUBLIC ACT 9266.		
NOTE: THIS DRAWING, AS AN INSTRUMENT OF SERVICE IS THE PROPERTY OF : BATAAN PENINSULA STATE UNIVERSITY AND AS SUCH MUST NOT BE REPRODUCED OR COPIED IN PART OR IN WHOLE WITHOUT THEIR PERMISSION ALL DRAWINGS ARE TO BE RETURNED WHEN NO LONGER IN USE.		
SHEET CONTENT:		SHEET NUMBER:
LOWER LEVEL LIGHTING LAYOUT		E-AC-01

NOTE : WRITTEN DIMENSIONS ON THESE DRAWINGS SHALL HAVE PRECEDENCE OVER SCALED DIMENSIONS. CONTRACTORS SHALL VERIFY AND BE RESPONSIBLE FOR ALL DIMENSIONS. ANY DISCREPANCY ON ALL DRAWINGS & SPECIFICATIONS SHALL BE THE RESPONSIBILITY OF THE CONTRACTOR. ANY DISCREPANCY IN MECHANICAL, ELECTRICAL, OR PLUMBING SHALL BE THE RESPONSIBILITY OF THE CONTRACTOR. VARIATIONS FROM THE DIMENSIONS AND CONDITIONS SHOWN BY THESE DRAWINGS SHALL BE THE RESPONSIBILITY OF THE CONTRACTOR.

NOTE : IF IN DOUBT, ASK FOR CLARIFICATION. DO NOT SCALE.

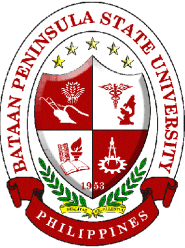


BATAAN PENINSULA STATE UNIVERSITY
TECHNICAL WORKING GROUP FOR INFRASTRUCTURE

CAPITAL COMPOUND, BRGY. TENEJERO, CITY OF BALANGA, BATAAN
E-MAIL: bpsu.twg@bpsu.edu.ph / bpsu.twg@bpsu.edu.ph
TELEPHONE NO. : (047) 237-15-98

LEGENDS AND SYMBOLS

○	6w, PINLIGHT ROUND RECESSED TYPE, MR16 SOCKET
—	LED LINEAR LIGHT (1200mm x 50mm) RECESSED TYPE
⤵	HOMERUN
co Ⓢ	CONVENIENCE OUTLET

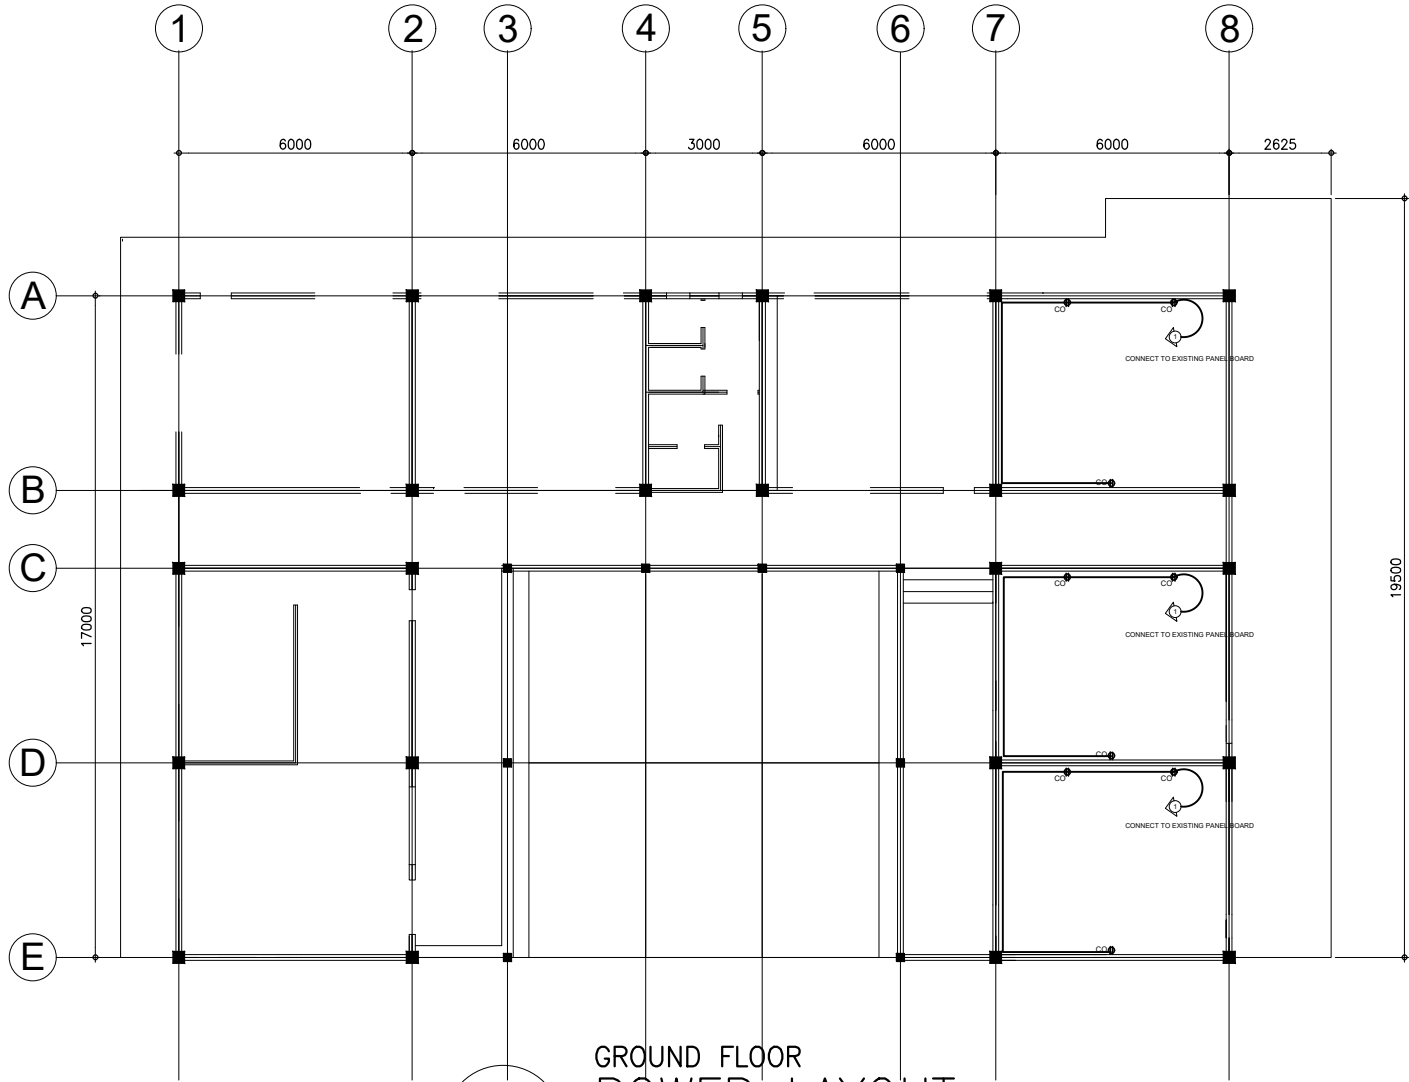

GROUND FLOOR
POWER LAYOUT
SCALE : 1:100 MTS.

PROJECT TITLE:

COMPLETION OF ORGANIC
AGRICULTURE RESEARCH AND
DEVELOPMENT FACILITY

LOCATION:
BATAAN PENINSULA STATE UNIVERSITY (ABUCAY CAMPUS)
ABUCAY, BATAAN

STRUCTURAL ENGINEER
REG. NO. :
PTR. NO. :
PLACE :
TN. NO. :

MASTER PLUMBER/SANITARY ENGINEER
REG. NO. :
PTR. NO. :
PLACE :
TN. NO. :

PROFESSIONAL ELECTRICAL ENGINEER
REG. NO. :
PTR. NO. :
PLACE :
TN. NO. :

PROFESSIONAL MECHANICAL ENGINEER
REG. NO. :
PTR. NO. :
PLACE :
TN. NO. :

REVISION		
NO.	DESCRIPTION	DATE
1		
2		

PREPARED BY:

AR. ROXETTE S. UMEREZ
ARCHITECT 1, BPSU TWG
REG. NO. :
PTR. NO. :
PLACE :
TN. NO. :

REVIEWED BY:

AR. RENIEL M. MAUSISA
ARCHITECT 1, BPSU TWG
REG. NO. :
PTR. NO. :
PLACE :
TN. NO. :

NOTED BY:

ENGR. ALFREDO D. VALENTOS
DIRECTOR OF PPES

RECOMMENDED BY:

DR. EDMUNDO C. TUNGOL
VICE PRESIDENT ADMIN. & FINANCE

APPROVED BY:


DR. GREGORIO J. RODIS
UNIVERSITY PRESIDENT

REPUBLIC ACT 9266.
NOTE: THIS DRAWING, AS AN INSTRUMENT OF SERVICE
IS THE PROPERTY OF : BATAAN PENINSULA STATE
UNIVERSITY AND AS SUCH MUST NOT BE
REPRODUCED OR COPIED IN PART OR IN WHOLE
WITHOUT THEIR PERMISSION ALL DRAWINGS ARE
TO BE RETURNED WHEN NO LONGER IN USE.

SHEET CONTENT:	SHEET NUMBER:
GROUND FLOOR POWER LAYOUT	E-AC-02


NOTE : WRITTEN DIMENSIONS ON THESE DRAWINGS SHALL HAVE PRECEDENCE OVER SCALED DIMENSIONS. CONTRACTORS SHALL VERIFY AND BE RESPONSIBLE FOR ALL DIMENSIONS SHOWN ON THESE DRAWINGS. ANY DISCREPANCY ON ALL DRAWINGS & SPECIFICATIONS SHALL BE THE RESPONSIBILITY OF THE CONTRACTOR. ANY VARIATIONS FROM THE DIMENSIONS AND CONDITIONS SHOWN BY THESE DRAWINGS SHALL BE SUBJECT FOR VERIFICATION AND APPROVAL BY THE ENGINEER.

NOTE : IF IN DOUBT, ASK FOR CLARIFICATION. DO NOT SCALE!

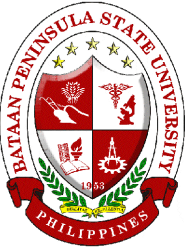

BATAAN PENINSULA STATE UNIVERSITY
TECHNICAL WORKING GROUP FOR INFRASTRUCTURE

CAPITAL COMPOUND, BRGY. TENILERO, CITY OF BALANGA, BATAAN
E-MAIL: bpsu.twginfra2016@gmail.com/ bpsupps2017@gmail.com
TELEPHONE NO. : (047) 237-15-98

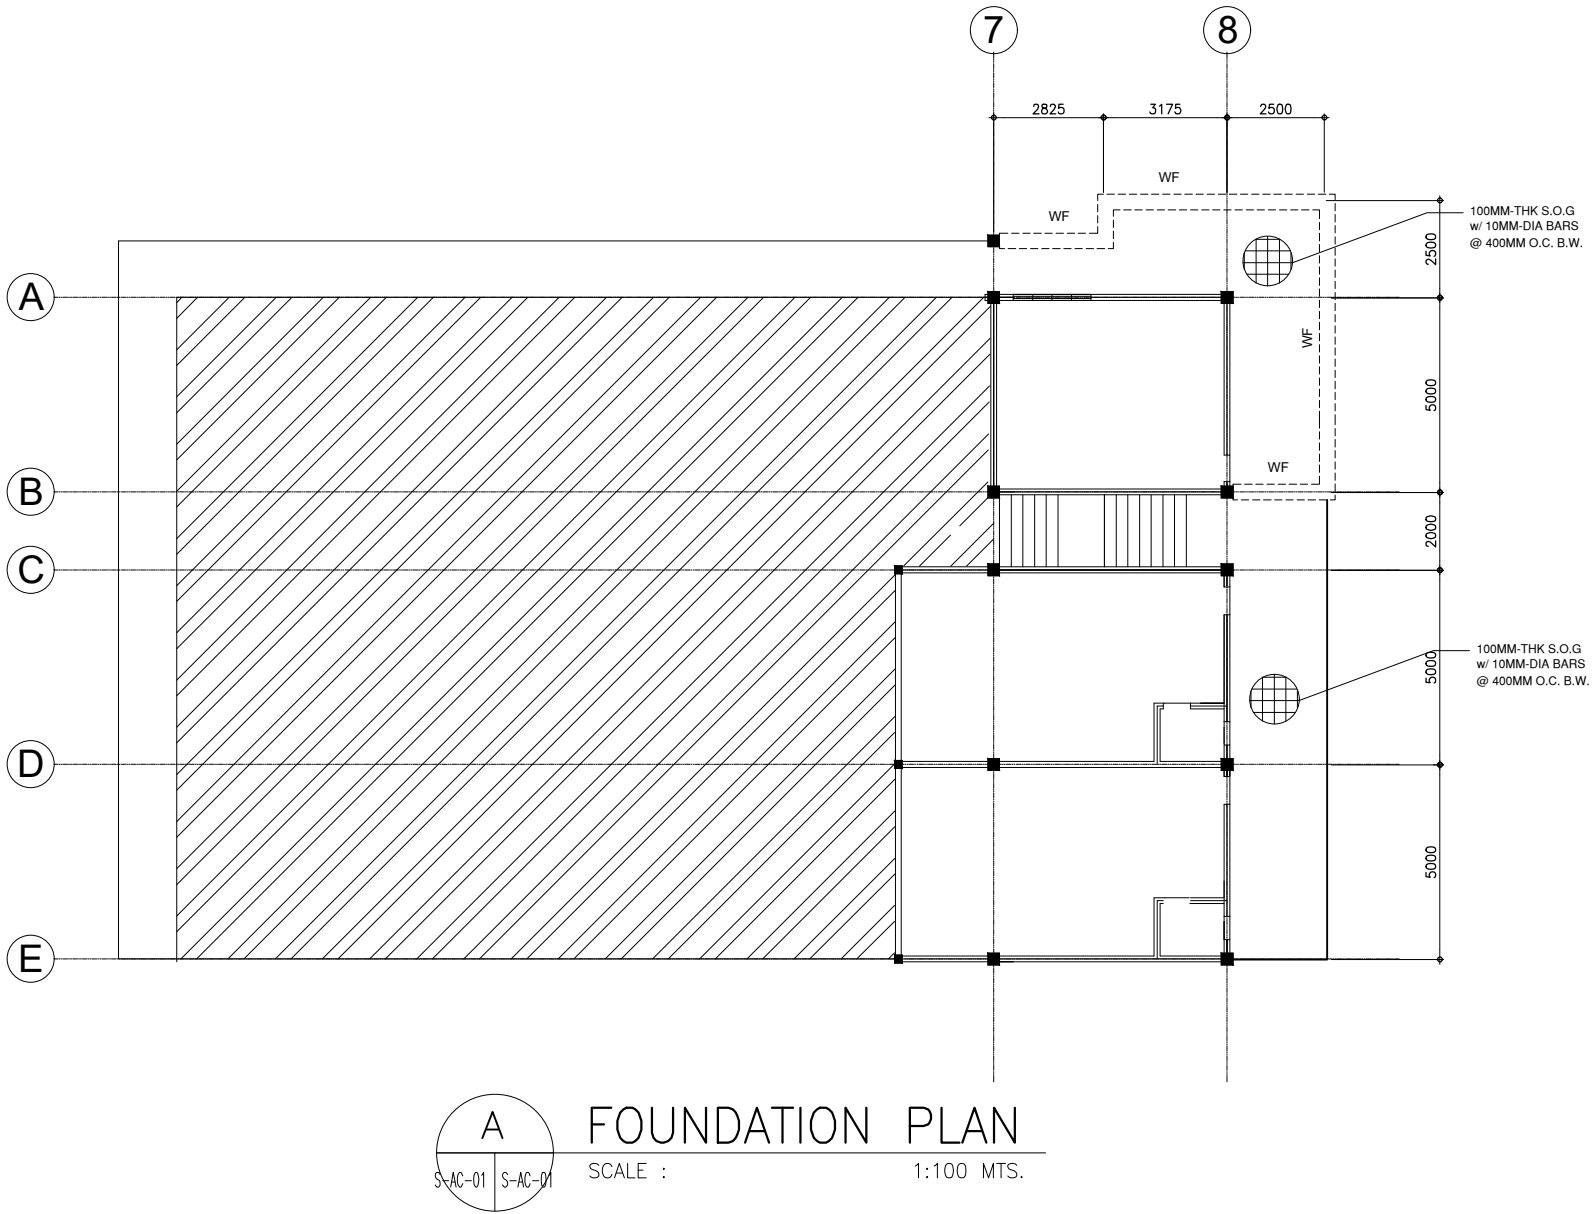

PROJECT TITLE:
COMPLETION OF ORGANIC
AGRICULTURE RESEARCH AND
DEVELOPMENT FACILITY

LOCATION:
BATAAN PENINSULA STATE UNIVERSITY (ABUCAY CAMPUS)
ABUCAY, BATAAN

STRUCTURAL ENGINEER
REG. NO. :
PTR. NO. :
PLACE :
TIN. NO. :

MASTER PLUMBER/SANITARY ENGINEER
REG. NO. :
PTR. NO. :
PLACE :
TIN. NO. :

PROFESSIONAL ELECTRICAL ENGINEER
REG. NO. :
PTR. NO. :
PLACE :
TIN. NO. :

PROFESSIONAL MECHANICAL ENGINEER
REG. NO. :
PTR. NO. :
PLACE :
TIN. NO. :

REVISION		
NO.	DESCRIPTION	DATE
1		
2		

PREPARED BY:
AR. ROXETTE S. UMEREZ
ARCHITECT 1, BPSU TWG

REG. NO. :
PTR. NO. :
PLACE :
TIN. NO. :

REVIEWED BY:
AR. RENIEL M. MAUSISA
ARCHITECT 1, BPSU TWG

NOTED BY:
ENGR. ALFREDO D. VALENTOS
DIRECTOR OF PPES

RECOMMENDED BY:
DR. EDMUNDO C. TUNGOL
VICE PRESIDENT ADMIN. & FINANCE


APPROVED BY:
DR. GREGORIO J. RODIS
UNIVERSITY PRESIDENT

REPUBLIC ACT 9266.
NOTE: THIS DRAWING, AS AN INSTRUMENT OF SERVICE
IS THE PROPERTY OF : BATAAN PENINSULA STATE
UNIVERSITY AND AS SUCH MUST NOT BE
REPRODUCED OR COPIED IN PART OR IN WHOLE
WITHOUT THEIR PERMISSION ALL DRAWINGS ARE
TO BE RETURNED WHEN NO LONGER IN USE.

SHEET CONTENT: FOUNDATION PLAN
SHEET NUMBER: S-AC-01


NOTE : WRITTEN DIMENSIONS ON THESE DRAWINGS SHALL HAVE PRECEDENCE OVER SCALED DIMENSIONS. CONTRACTORS SHALL VERIFY AND BE RESPONSIBLE FOR ALL DIMENSIONS SHOWN ON THESE DRAWINGS. ANY DISCREPANCY ON ALL DRAWINGS & SPECIFICATIONS SHALL BE THE RESPONSIBILITY OF THE CONTRACTOR. ANY VARIATIONS FROM THE DIMENSIONS AND CONDITIONS SHOWN BY THESE DRAWINGS SHALL BE SUBJECT FOR VERIFICATION AND APPROVAL BY THE ENGINEER.

NOTE : IF IN DOUBT, ASK FOR CLARIFICATION. DO NOT SCALE!

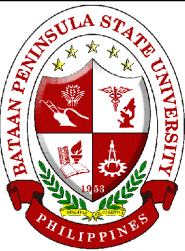

BATAAN PENINSULA STATE UNIVERSITY
TECHNICAL WORKING GROUP FOR INFRASTRUCTURE

CAPITAL COMPOUND, BRGY. TENEJERO, CITY OF BALANGA, BATAAN.
E-MAIL: bpsu.twginfra2016@gmail.com/ bpsupps2017@gmail.com
TELEPHONE NO. : (047) 237-15-98

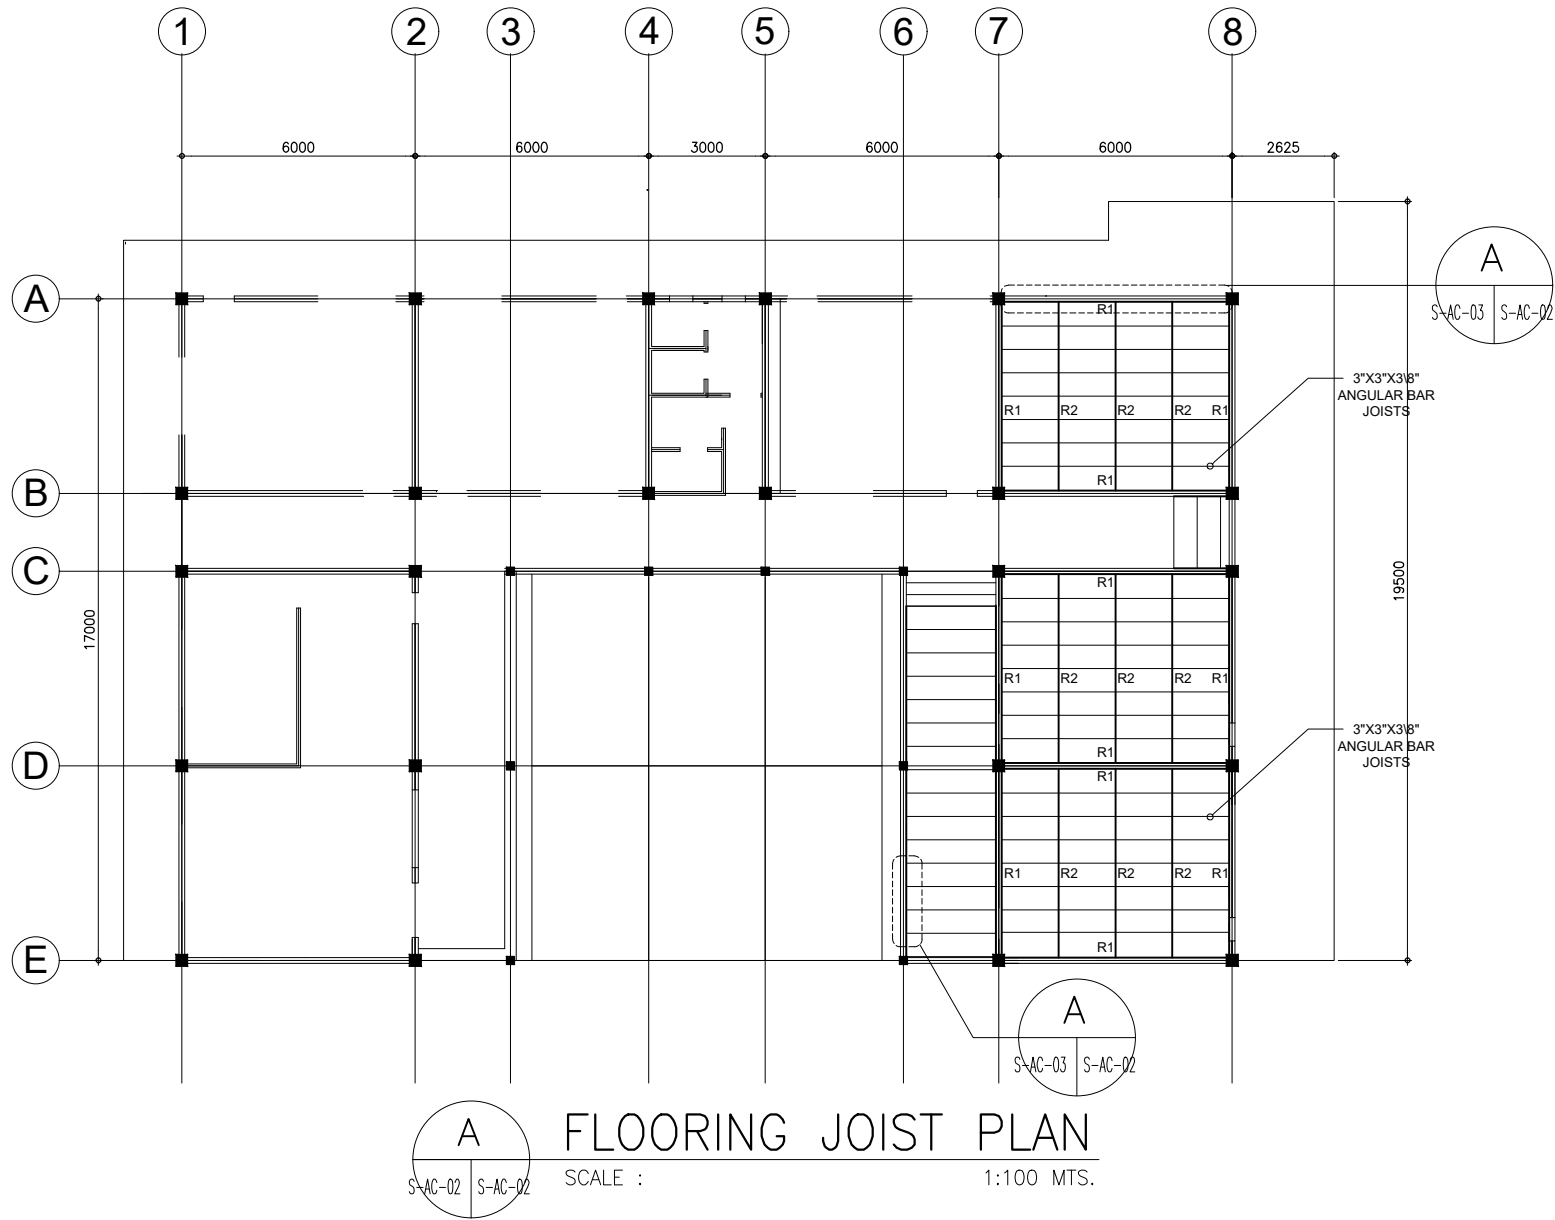

PROJECT TITLE:
COMPLETION OF ORGANIC
AGRICULTURE RESEARCH AND
DEVELOPMENT FACILITY

LOCATION:
BATAAN PENINSULA STATE UNIVERSITY (ABUCAY CAMPUS)
ABUCAY, BATAAN

STRUCTURAL ENGINEER
REG. NO. :
PTR. NO. :
PLACE :
TN. NO. :

MASTER PLUMBER/SANITARY ENGINEER
REG. NO. :
PTR. NO. :
PLACE :
TN. NO. :

PROFESSIONAL ELECTRICAL ENGINEER
REG. NO. :
PTR. NO. :
PLACE :
TN. NO. :

PROFESSIONAL MECHANICAL ENGINEER
REG. NO. :
PTR. NO. :
PLACE :
TN. NO. :

REVISION		
NO.	DESCRIPTION	DATE
1		
2		

PREPARED BY:
AR. ROXETTE S. UMEREZ
ARCHITECT 1, BPSU TWG
REG. NO. :
PTR. NO. :
PLACE :
TN. NO. :

REVIEWED BY:
AR. RENIEL M. MAUSISA
ARCHITECT 1, BPSU TWG
REG. NO. :
PTR. NO. :
PLACE :
TN. NO. :


NOTED BY:
ENGR. ALFREDO D. VALENTOS
DIRECTOR OF PPES
REG. NO. :
PTR. NO. :
PLACE :
TN. NO. :

RECOMMENDED BY:
DR. EDMUNDO C. TUNGOL
VICE PRESIDENT ADMIN. & FINANCE
REG. NO. :
PTR. NO. :
PLACE :
TN. NO. :

APPROVED BY:
DR. GREGORIO J. RODIS
UNIVERSITY PRESIDENT
REG. NO. :
PTR. NO. :
PLACE :
TN. NO. :


REPUBLIC ACT 9266.
NOTE: THIS DRAWING, AS AN INSTRUMENT OF SERVICE
IS THE PROPERTY OF : BATAAN PENINSULA STATE
UNIVERSITY AND AS SUCH MUST NOT BE
REPRODUCED OR COPIED IN PART OR IN WHOLE
WITHOUT THEIR PERMISSION ALL DRAWINGS ARE
TO BE RETURNED WHEN NO LONGER IN USE.

SHEET CONTENT: FRAMING PLAN
SHEET NUMBER: S-AC-02

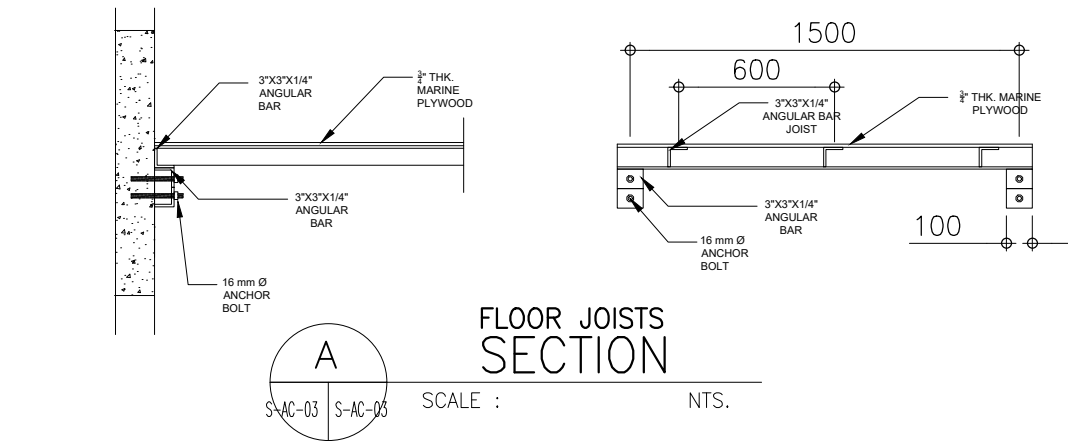


FLOOR JOISTS
SECTION

SCALE : NTS.

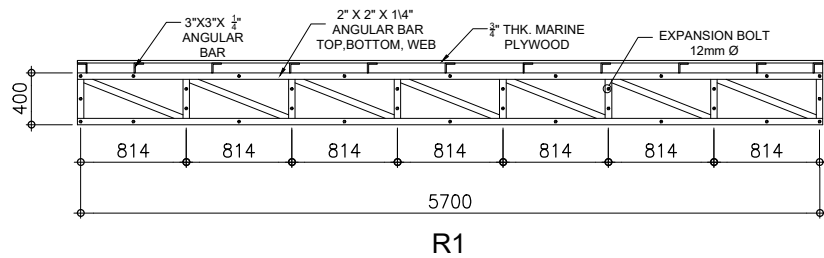


RAFTER 1 DETAIL

SCALE : NTS.

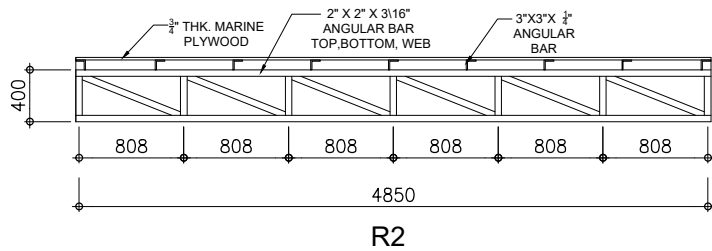


RAFTER 2 DETAIL

SCALE : NTS.

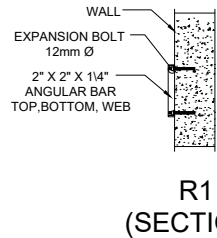

R1
(SECTION)

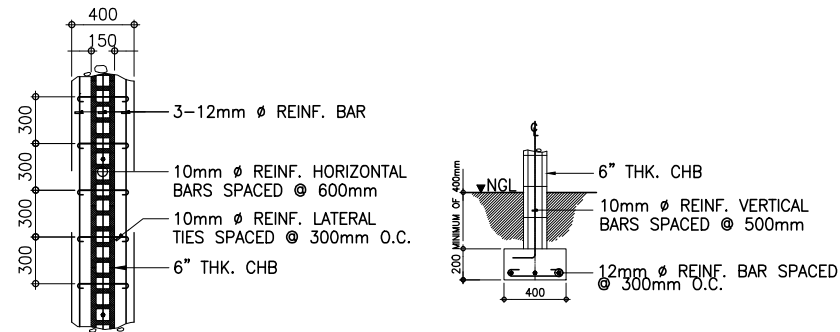


PLAN

SECTION

WALL FOOTING DETAIL

SCALE : NTS.

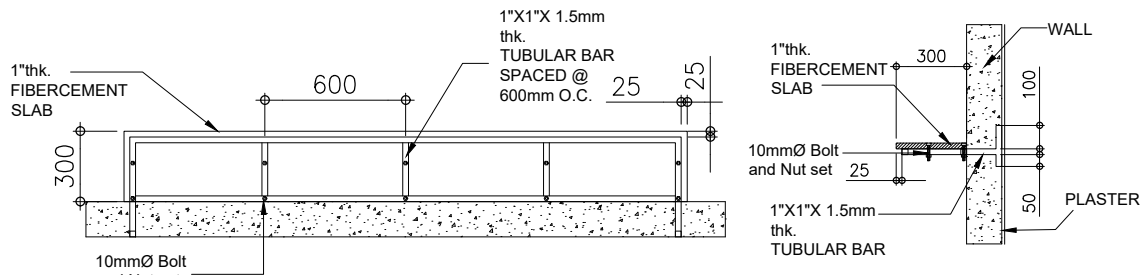

CANOPY DETAIL

SCALE : NTS.

PROJECT TITLE:
COMPLETION OF ORGANIC
AGRICULTURE RESEARCH AND
DEVELOPMENT FACILITY

LOCATION:
BATAAN PENINSULA STATE UNIVERSITY (ABUCAY CAMPUS)
ABUCAY, BATAAN

STRUCTURAL ENGINEER
REG. NO. :
PTR. NO. :
PLACE :
TN. NO. :

MASTER PLUMBER/SANITARY ENGINEER
REG. NO. :
PTR. NO. :
PLACE :
TN. NO. :

PROFESSIONAL ELECTRICAL ENGINEER
REG. NO. :
PTR. NO. :
PLACE :
TN. NO. :

PROFESSIONAL MECHANICAL ENGINEER
REG. NO. :
PTR. NO. :
PLACE :
TN. NO. :

REVISION		
NO.	DESCRIPTION	DATE
1		
2		

PREPARED BY:
AR. ROXETTE S. UMEREZ
ARCHITECT 1, BPSU TWG

REVIEWED BY:
AR. RENIEL M. MAUSISA
ARCHITECT 1, BPSU TWG


NOTED BY:
ENGR. ALFREDO D. VALENTOS
DIRECTOR OF PPES

RECOMMENDED BY:
DR. EDMUNDO C. TUNGOL
VICE PRESIDENT ADMIN. & FINANCE

APPROVED BY:
DR. GREGORIO J. RODIS
UNIVERSITY PRESIDENT

REPUBLIC ACT 9266.
NOTE: THIS DRAWING, AS AN INSTRUMENT OF SERVICE
IS THE PROPERTY OF : BATAAN PENINSULA STATE
UNIVERSITY AND AS SUCH MUST NOT BE
REPRODUCED OR COPIED IN PART OR IN WHOLE
WITHOUT THEIR PERMISSION ALL DRAWINGS ARE
TO BE RETURNED WHEN NO LONGER IN USE.

SHEET CONTENT: DETAILS
SHEET NUMBER: S-AC-03

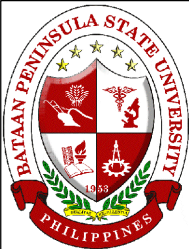

BATAAN PENINSULA STATE UNIVERSITY
TECHNICAL WORKING GROUP FOR INFRASTRUCTURE
CAPITAL COMPOUND, BRGY. TENILERO, CITY OF BALANGA, BATAAN
E-MAIL: bpsu.twg@bpsu.edu.ph / bpsu.twg@bpsu.edu.ph
TELEPHONE NO. : (047) 237-15-98