

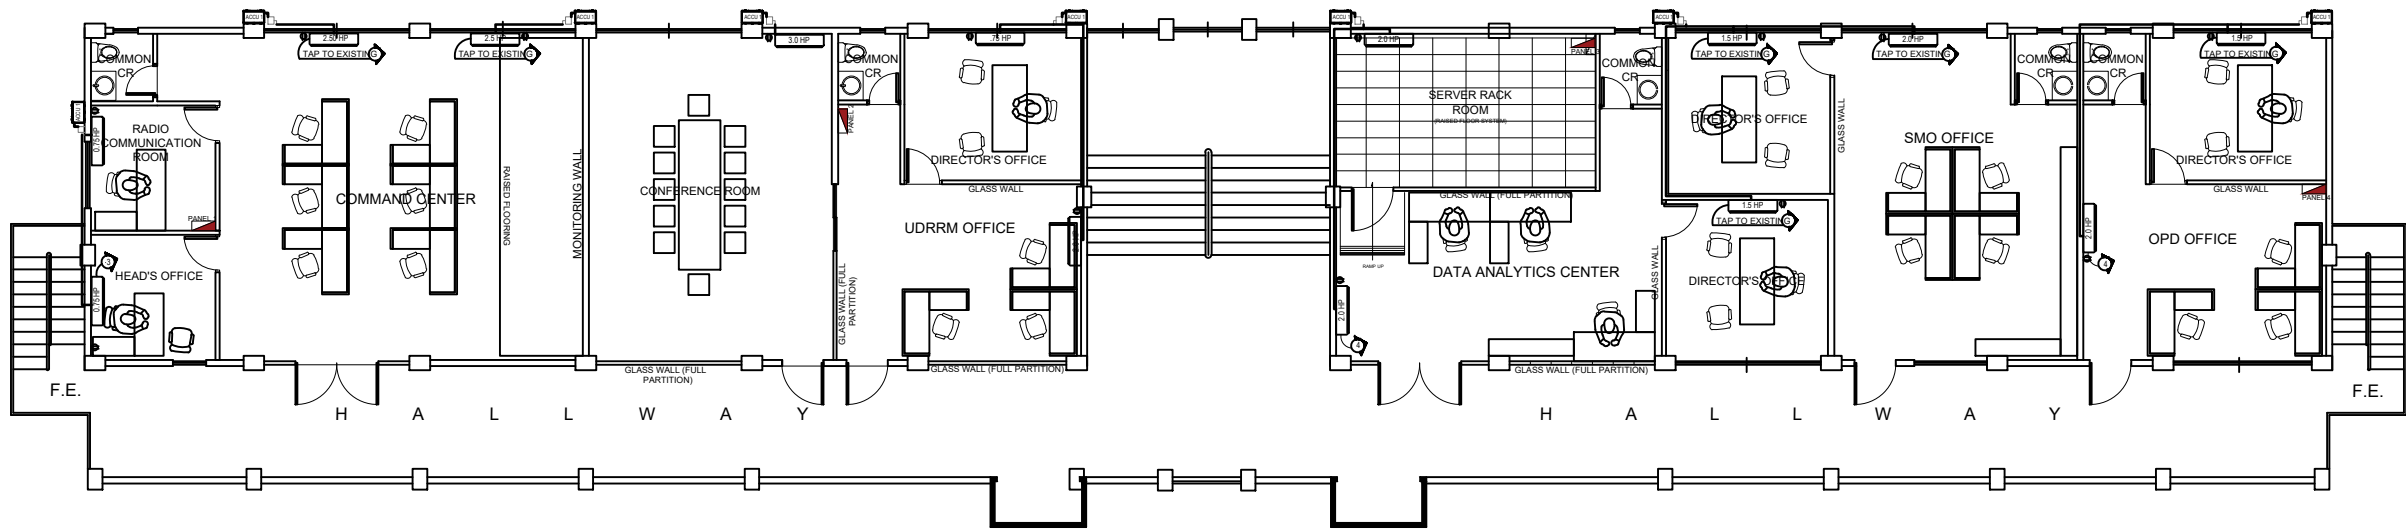
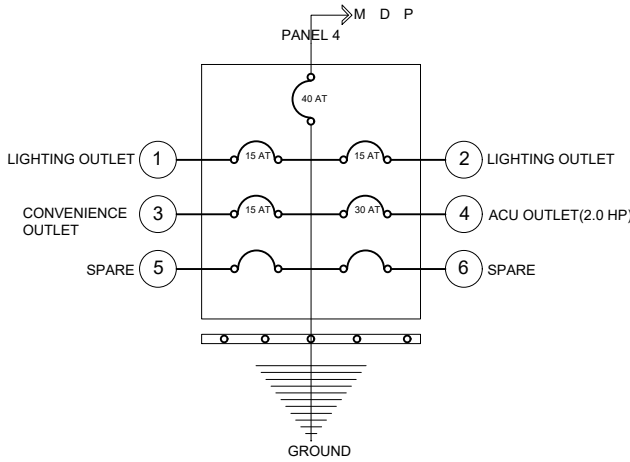
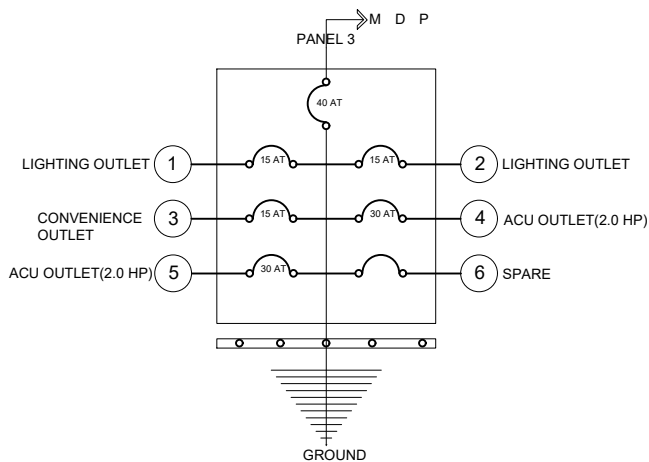


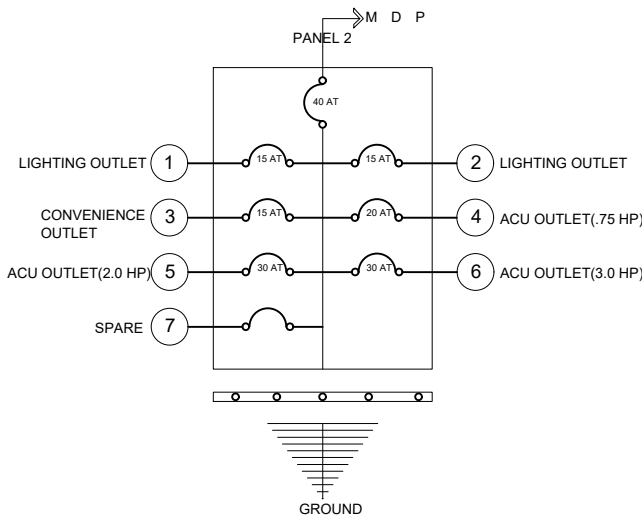

CANOPY

(THIRD FLOOR PLAN)
ACU LAYOUT
SCALE : 1:100 MTS

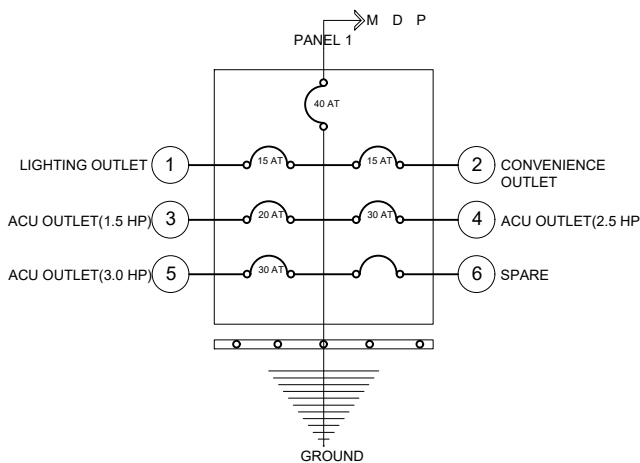

LEGENDS AND SYMBOLS

	LED TROFFER LIGHT(600mmX1200mm)
	LED 6W SQUARE DAYLIGHT DOWNLIGHT
	LED LIGHT SENSOR MOTION
	LED STRIP ALUMINUM LIGHT
S1	1 GANG SWITCH
S2	2 GANG SWITCH
S3	3 GANG SWITCH
	2 GANG DUPLEX CON.OUTLET
	DESK POP UP OUTLET
	CIRCUIT HOMERUN
	CIRCUIT LINE
	CIRCUIT BREAKER
	SERVICE ENTRANCE
	PANEL BOARD
	ACU OUTLET

PROJECT TITLE:		
CONVERSION OF ESF THIRD FLOOR BUILDING INTO BPSU COMMAND CENTER AT BPSU MAIN CAMPUS		
LOCATION:		
BATAAN PENINSULA STATE UNIVERSITY MAIN CAMPUS		
STRUCTURAL ENGINEER		
RES. NO. :		
PRL. NO. :		
PLACE :		
TIN NO. :		
MASTER PLUMBER/SANITARY ENGINEER		
RES. NO. :		
PRL. NO. :		
PLACE :		
TIN NO. :		
PROFESSIONAL ELECTRICAL ENGINEER		
RES. NO. :		
PRL. NO. :		
PLACE :		
TIN NO. :		
PROFESSIONAL MECHANICAL ENGINEER		
RES. NO. :		
PRL. NO. :		
PLACE :		
TIN NO. :		
REVISION		
NO.	DESCRIPTION	DATE
2		
PREPARED BY:		
AR. ROXETTE S. UMEREZ		
ARCHITECT 1, BPSU TWG HEAD FOR INFRASTRUCTURE		
RES. NO. :		
PRL. NO. :		
PLACE :		
REVIEWED BY:		
JASON ANTHONY B. BANZON		
CAMPUS DIRECTOR		
RES. NO. :		
PRL. NO. :		
PLACE :		
NOTED BY:		
ENGR. ALFREDO D. VALENTOS		
DIRECTOR, PPES		
RECOMMENDED BY:		
DR. EDMUNDO C. TUNGOL		
VICE PRESIDENT ADMIN. & FINANCE		
APPROVED BY:		
DR. GREGORIO J. RODIS		
UNIVERSITY PRESIDENT		
REPUBLIC ACT 9266.		
NOTE: THIS DRAWING, AS AN INSTRUMENT OF SERVICE, IS THE PROPERTY OF : BATAAN PENINSULA STATE UNIVERSITY AND AS SUCH MUST NOT BE REPRODUCED OR COPIED IN PART OR IN WHOLE WITHOUT THEIR PERMISSION. ALL DRAWINGS ARE TO BE RETURNED WHEN NO LONGER IN USE.		
SHEET CONTENT:		SHEET NUMBER:
• ACU LAYOUT • RISER DIAGRAM • LEGENDS AND SYMBOL		E-MC-02



BATAAN PENINSULA STATE UNIVERSITY
TECHNICAL WORKING GROUP FOR INFRASTRUCTURE
CAPITOL COMPOUND, BROY, TENEKERO, CITY OF BALANGA, BATAAN,
E-MAIL: bpsu.techinfo2016@gmail.com/ bpsu.techinfo2017@gmail.com
TELEPHONE NO. : (047) 237-15-08

NOTE : DIMENSIONS ON THESE DRAWINGS SHALL HAVE PRECEDENCE OVER SHOWN DIMENSIONS. CONTRACTORS SHALL VERIFY AND BE RESPONSIBLE FOR ALL DIMENSIONS AND CONDITIONS ON THE JOB. THE DESIGNER MUST BE NOTIFIED IMMEDIATELY OF ANY VARIATIONS FROM THE DIMENSIONS AND CONDITIONS SHOWN BY THESE DRAWINGS.