



NOTE : WRITTEN DIMENSIONS ON THESE DRAWINGS SHALL HAVE PRECEDENCE OVER SCALED DIMENSIONS. CONTRACTORS SHALL VERIFY AND BE RESPONSIBLE FOR ALL DIMENSIONS & SPECIFICATIONS AND CONDITIONS ON THE JOB. THE DESIGNER MUST BE NOTIFIED IMMEDIATELY OF ANY VARIATIONS FROM THE DIMENSIONS AND CONDITIONS SHOWN BY THESE DRAWINGS.

NOTE : DIMENSIONS ON ALL DRAWINGS & SPECIFICATIONS (ARCHITECTURAL, STRUCTURAL, SANITARY, ELECTRICAL, MECHANICAL ETC.) SHALL BE SUBJECT FOR VERIFICATION AND DO NOT SCALE.

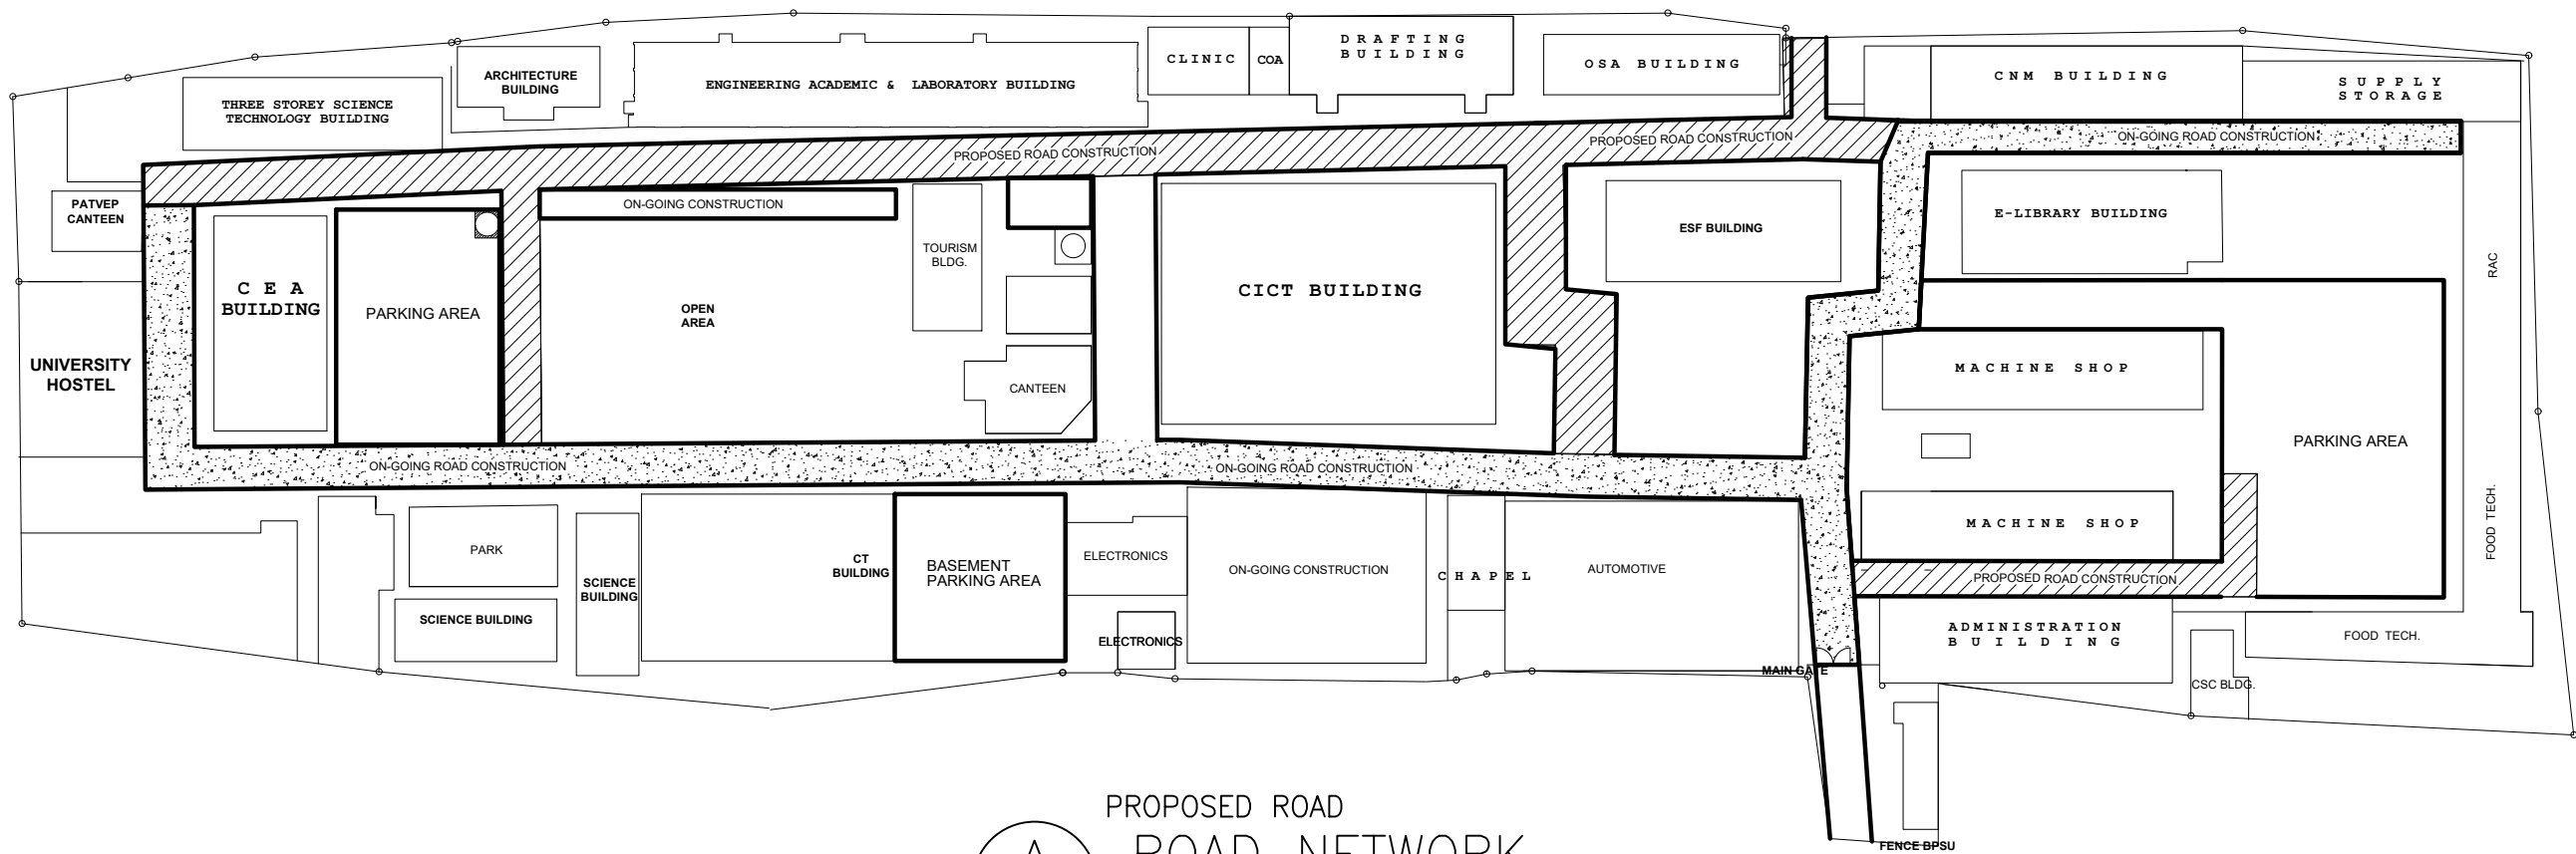

PROPOSED ROAD
A ROAD NETWORK
SCALE : NTS.

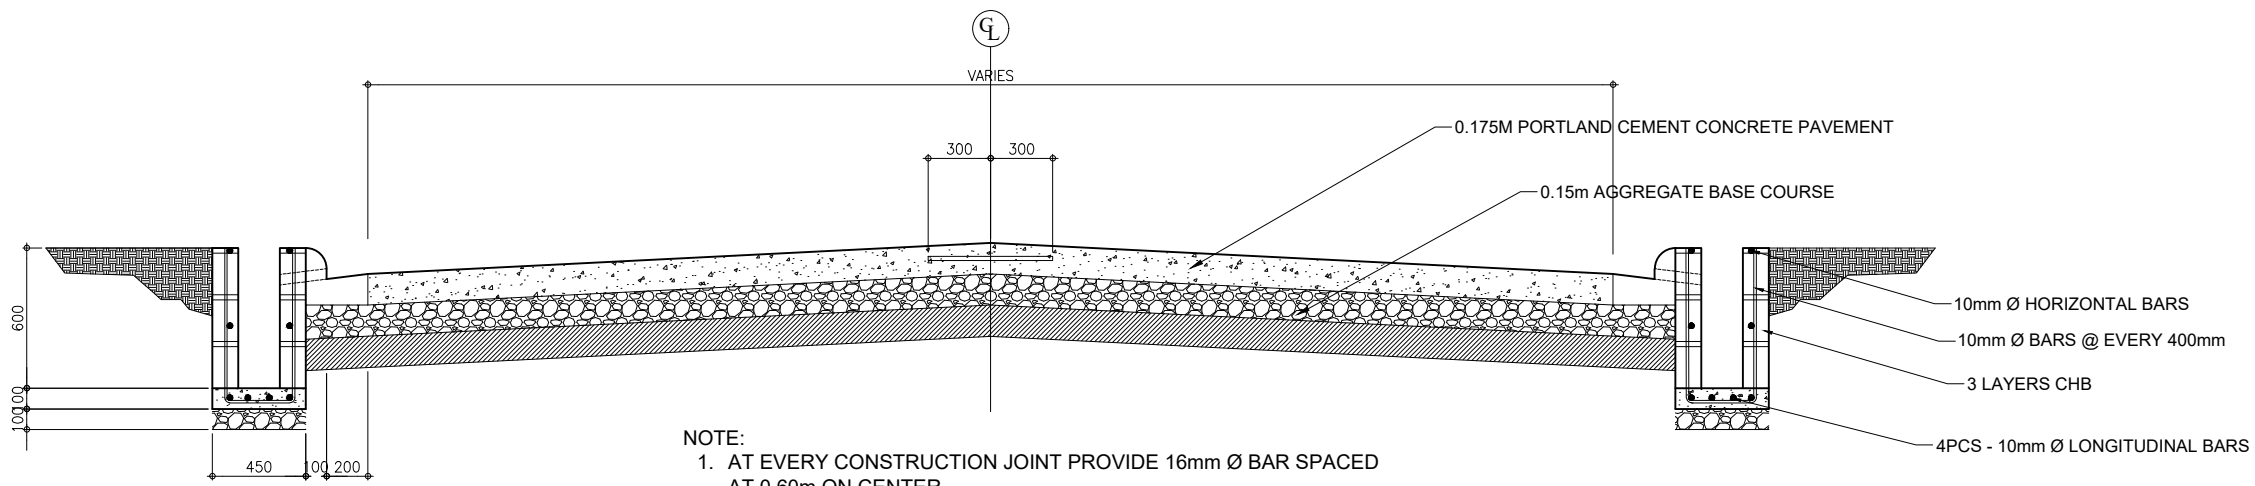

NOTE:
1. AT EVERY CONSTRUCTION JOINT PROVIDE 16mm Ø BAR SPACED AT 0.60m ON CENTER

PROPOSED ROAD
B ROAD SECTION
SCALE : NTS.

BATAAN PENINSULA STATE UNIVERSITY
TECHNICAL WORKING GROUP FOR INFRASTRUCTURE
CAPITOL COMPOUND, BRGY. TENJERO, CITY OF BALANGA, BATAAN,
E-MAIL: bpsu.tech@bpu.edu.ph / bpsu.tech@bpu.edu.ph
TELEPHONE NO. : (0477) 237-15-98

PROJECT TITLE
PROPOSED COMPLETION OF ROAD NETWORK AT BPSU MAIN CAMPUS

LOCATION
BATAAN PENINSULA STATE UNIVERSITY (MAIN CAMPUS)
BALANGA CITY, BATAAN

STRUCTURAL ENGINEER
REG. NO. :
P.R. NO. :
PLACE :
TIN NO. :

MASTER PLUMBER/SANITARY ENGINEER
REG. NO. :
P.R. NO. :
PLACE :
TIN NO. :

PROFESSIONAL ELECTRICAL ENGINEER
REG. NO. :
P.R. NO. :
PLACE :
TIN NO. :

PROFESSIONAL MECHANICAL ENGINEER
REG. NO. :
P.R. NO. :
PLACE :
TIN NO. :

REVISION
NO. DESCRIPTION DATE
2

PREPARED BY:
AR. ROXETTE S. UMEREZ
ARCHITECT 1, BPSU TWG

CHECKED BY:
JASON ANTHONY B. BANZON
CAMPUS DIRECTOR

REVIEWED BY:
ENGR. ALFREDO D. VALENTOS
PPES DIRECTOR

RECOMMENDED BY:
DR. EDMUNDO C. TUNGOL
VICE PRESIDENT ADMIN. & FINANCE

APPROVED BY:
DR. GREGORIO J. RODIS
UNIVERSITY PRESIDENT

REPUBLIC ACT 9266.
NOTE: THIS DRAWING, AS AN INSTRUMENT OF SERVICE IS THE PROPERTY OF : BATAAN PENINSULA STATE UNIVERSITY AND AS SUCH MUST NOT BE REPRODUCED OR COPIED IN PART OR IN WHOLE WITHOUT THEIR PERMISSION ALL DRAWINGS ARE TO BE RETURNED WHEN NO LONGER IN USE.

SHEET CONTENT: SHEET NUMBER
• FLOOR PLAN
• SECTION OF ROAD
A-AC-01