



NOTE: ALL DIMENSIONS ON THESE DRAWINGS SHALL HAVE PRECEDENCE OVER SCALED DIMENSIONS. CONTRACTORS SHALL VERIFY AND BE RESPONSIBLE FOR ALL DIMENSIONS AND CONDITIONS ON THE JOB. THE DESIGNER MUST BE NOTIFIED IMMEDIATELY OF ANY VARIATIONS FROM THE DIMENSIONS AND CONDITIONS SHOWN BY THESE DRAWINGS.

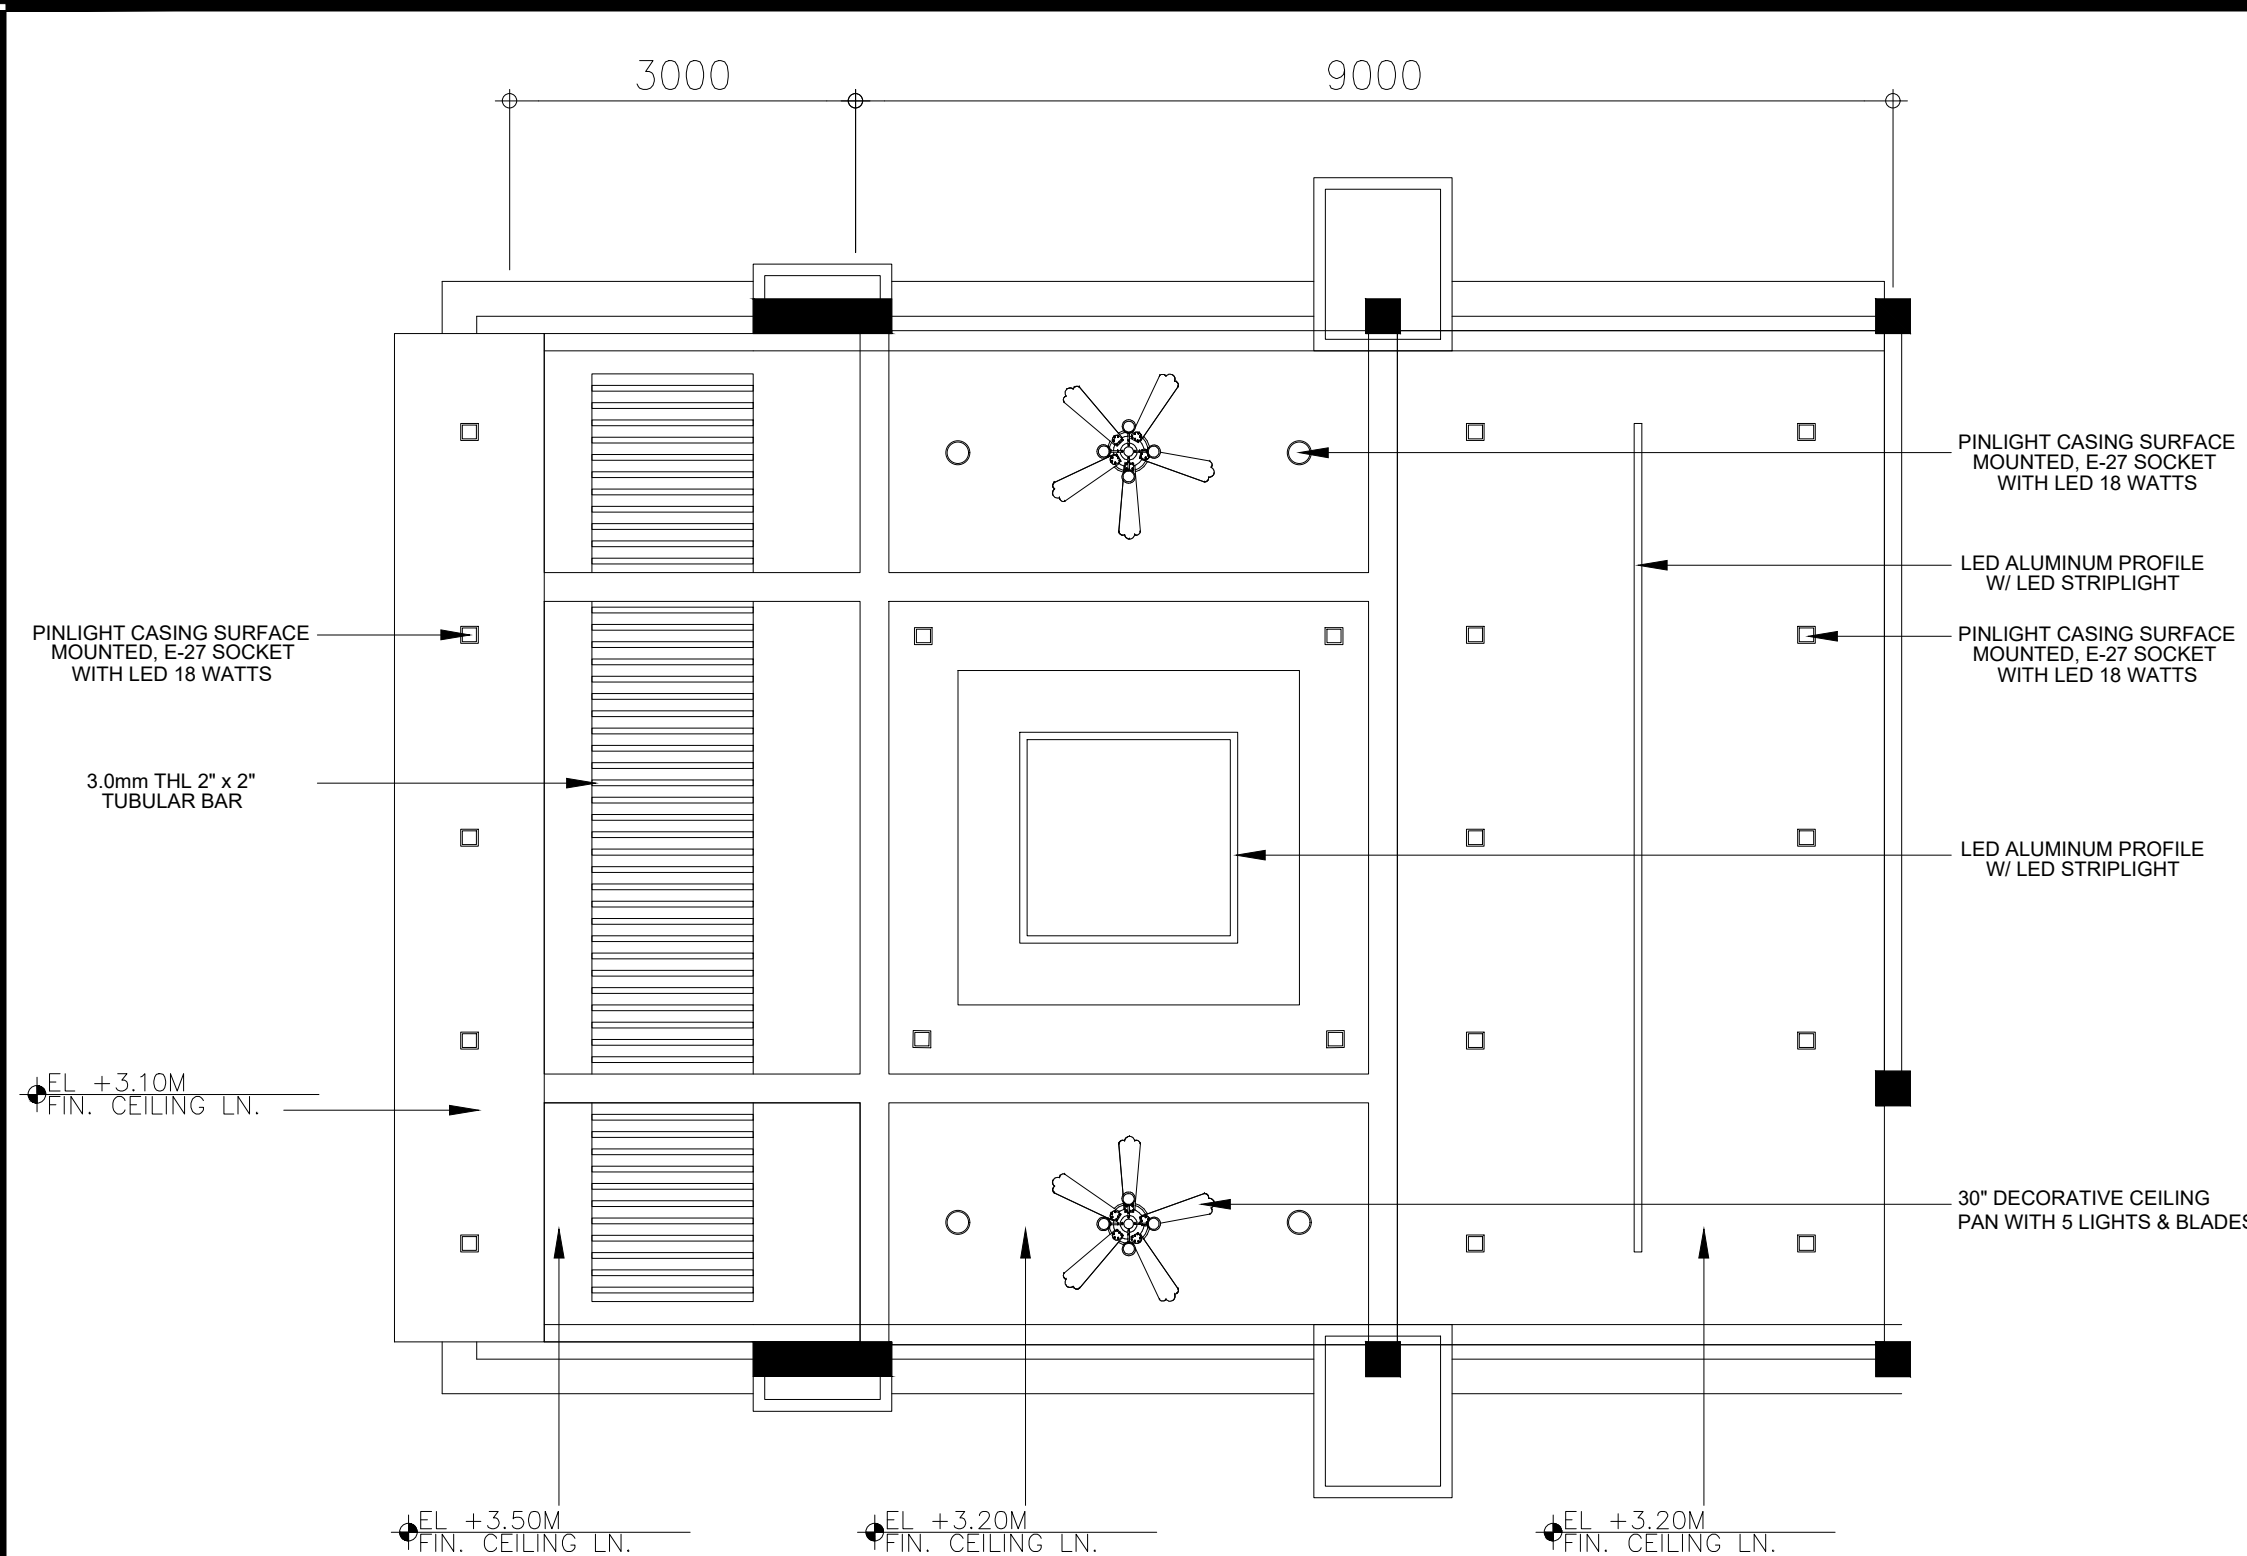


BLOW-UP PLAN (REFLECTED CEILING PLAN)
1 STUDENT LOUNGE
SCALE 1:40 MTS

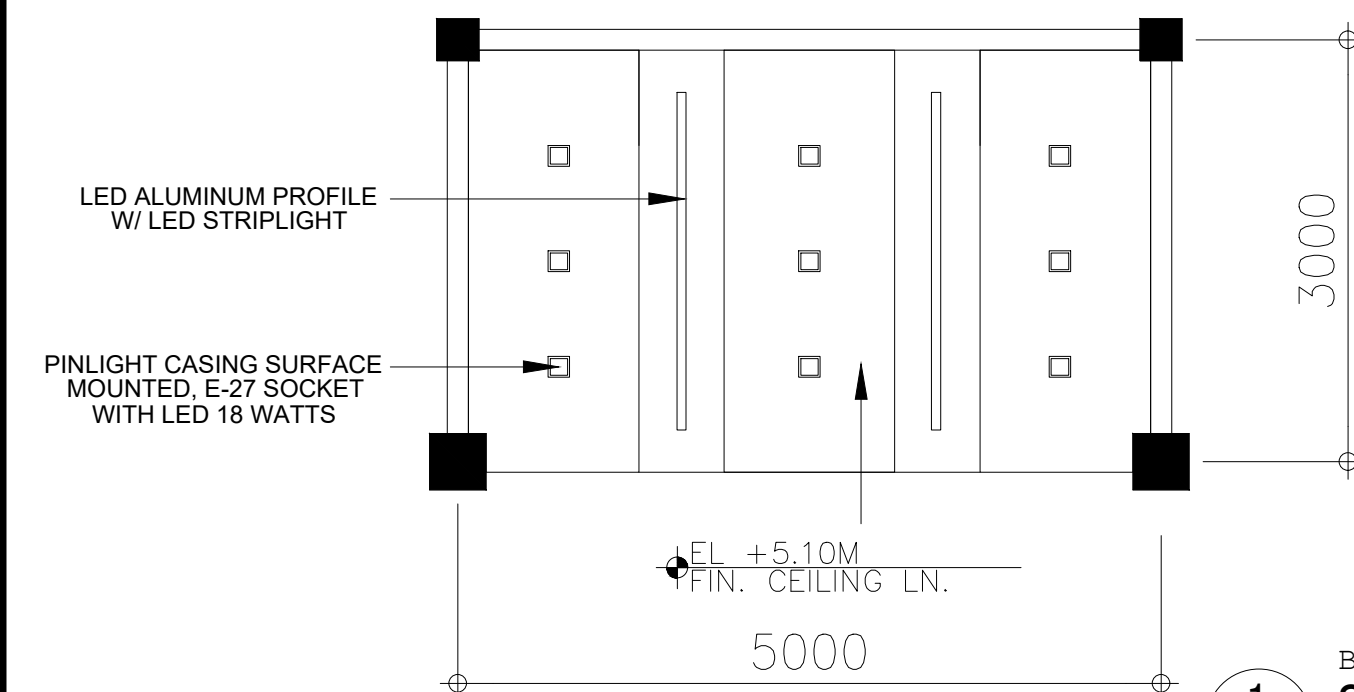

BLOW-UP PLAN (REFLECTED CEILING PLAN)
1 S T A G E
SCALE 1:50 MTS

LEGEND & SYMBOL

- 3'6w LED DOWNLIGHT SURFACE MOUNTED
- 7'1w LED DOWNLIGHT RECESSED TYPE
- IN-CEILING SPEAKER
- WALL SPEAKER
- 4'3W RGBW LED BEAM LIGHT (MOVING HEAD)
- LED ALUMINUM PROFILE W/ LED STRIPLIGHT

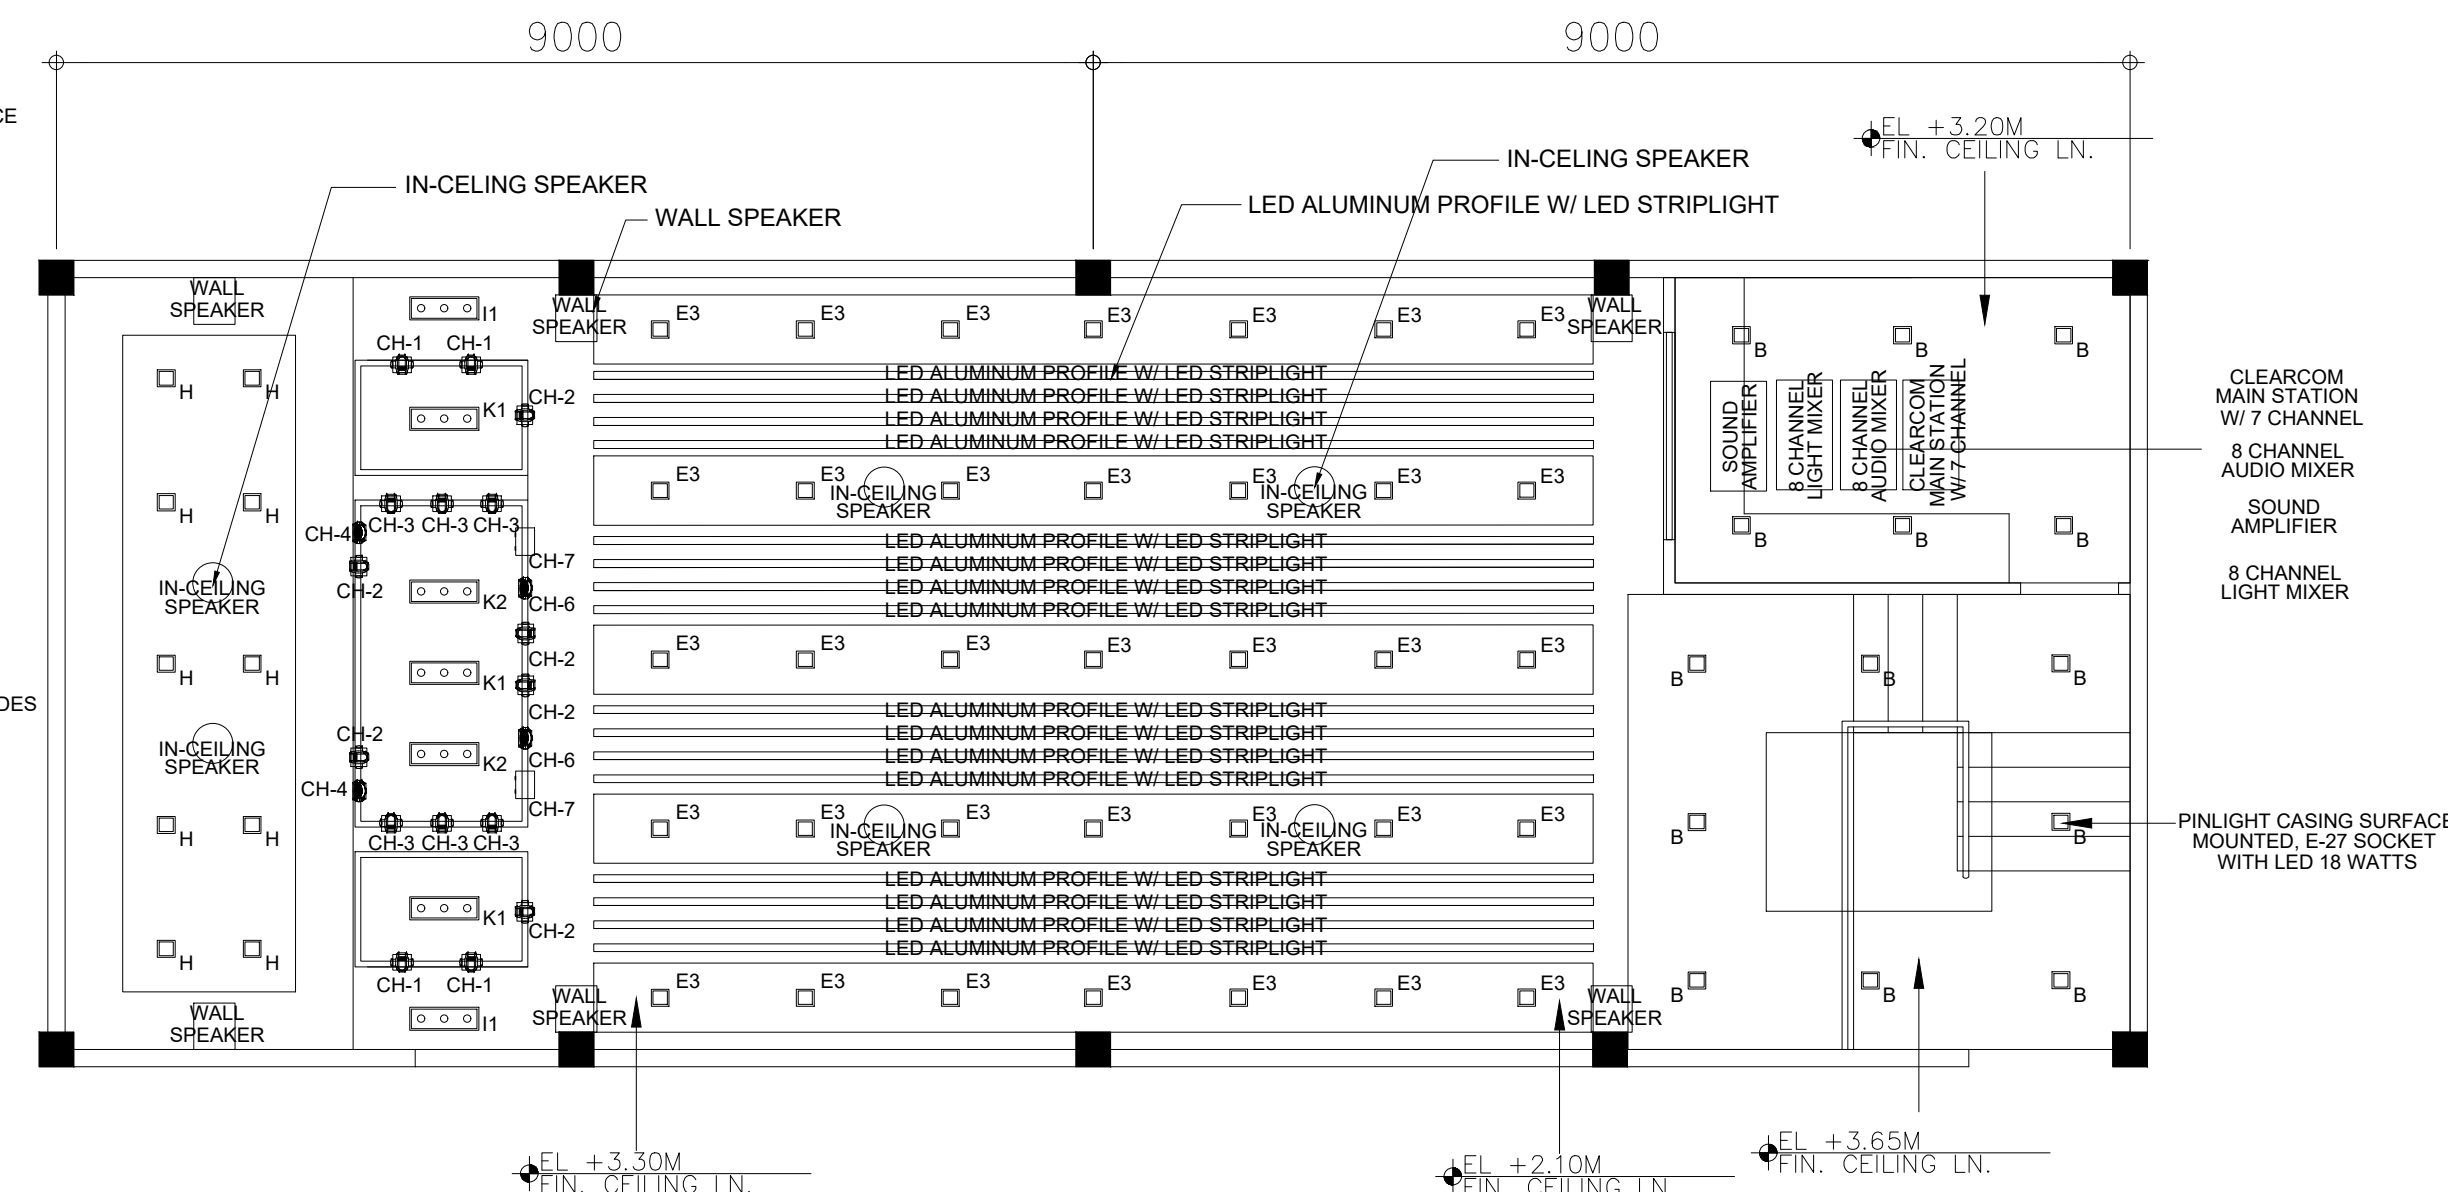

BLOW-UP PLAN (REFLECTED CEILING PLAN)
2 MINI-AMPHITHEATER
SCALE 1:50 MTS



BATAAN PENINSULA STATE UNIVERSITY
TECHNICAL WORKING GROUP FOR INFRASTRUCTURE
CAPITOL COMPOUND, BRGY. TENEJERO, CITY OF BALANGA, BATAAN,
E-MAIL: bpsu.twginfra2016@gmail.com/ bpsupes2017@gmail.com
TELEPHONE NO. : (047) 237-15-98

FLOOR FINISH SCHEDULE (FOR ARCHITECT'S APPROVAL)		WALL FINISH SCHEDULE (FOR ARCHITECT'S APPROVAL)		PARTITION SCHEDULE (FOR ARCHITECT'S APPROVAL)	
FF-1	60 x 60 CERAMIC NON-SKID TILES (DARK COLOR)	WF-1	30 cm x 60cm POLISHED CONCRETE TILES		
FF-2	60 cm x 60 cm POLISHED CERAMIC TILES				
FF-3	60 cm x 60cm NON-SKID CERAMIC TILES (LIGHT COLOR)				
FF-4	BROAD LOOMS FINISH CARPET				
FF-5	VITRIFIED CERAMIC TILES (WOOD FINISH)				
FF-6	60 x 60 CERAMIC NON-SKID TILES WITH ANTI SLIP THREAD NOSING				

REVISION	
NO.	DESCRIPTION
2	

PREPARED BY:	
AR. ROXETTE S. UMEREZ	
ARCHITECT 1, BPSU TWG	
REG. NO. :	
PTR. NO. :	
PLACE :	
TIN NO. :	
CHECKED BY:	
AR. JO-ANA MARI Z. TANEGA	
ARCHITECT 1, PPES OFFICE	
REG. NO. :	
PTR. NO. :	
PLACE :	
TIN NO. :	
NOTED BY:	
ENGR. ALFREDO D. VALENTOS	
DIRECTOR, PPES	
RECOMMENDED BY:	
DR. EDMUNDO C. TUNGOL	
VICE PRESIDENT ADMIN. & FINANCE	
APPROVED BY:	
DR. GREGORIO J. RODIS	
UNIVERSITY PRESIDENT	
REPUBLIC ACT 9266.	
NOTE: THIS DRAWING, AS AN INSTRUMENT OF SERVICE, IS THE PROPERTY OF : BATAAN PENINSULA STATE UNIVERSITY AND AS SUCH MUST NOT BE REPRODUCED OR COPIED IN PART OR IN WHOLE WITHOUT THEIR PERMISSION ALL DRAWINGS ARE TO BE RETURNED WHEN NO LONGER IN USE.	
SHEET CONTENT:	SHEET NUMBER:
• BLOW-UP PLAN • REFLECTED CEILING PLAN OF MINI-AMPHITHEATER & STUDENT LOUNGE	A-MPH-14