



NOTE : WRITTEN DIMENSIONS ON THESE DRAWINGS SHALL HAVE PRECEDENCE OVER SCALED DIMENSIONS. CONTRACTORS SHALL BE RESPONSIBLE FOR CHECKING DIMENSIONS AND CONDITIONS BEFORE THE ESCALATION OF ANY DISCREPANCY. ANY VARIATIONS FROM THE DIMENSIONS AND CONDITIONS SHOWN BY THESE DRAWINGS, SHALL BE SUBJECT FOR VERIFICATION.

NOTE : IF IN DOUBT, ASK! DO NOT SCALE!



BATAAN PENINSULA STATE UNIVERSITY
TECHNICAL WORKING GROUP FOR INFRASTRUCTURE

CAPITOL COMPOUND, BROY, TENGEIRO, CITY OF BALANGA, BATAAN,
E-MAIL : bpuu.reginfo2017@gmail.com / bpuugpe2017@gmail.com
TELEPHONE NO. : (047) 237-15-98

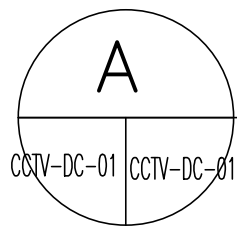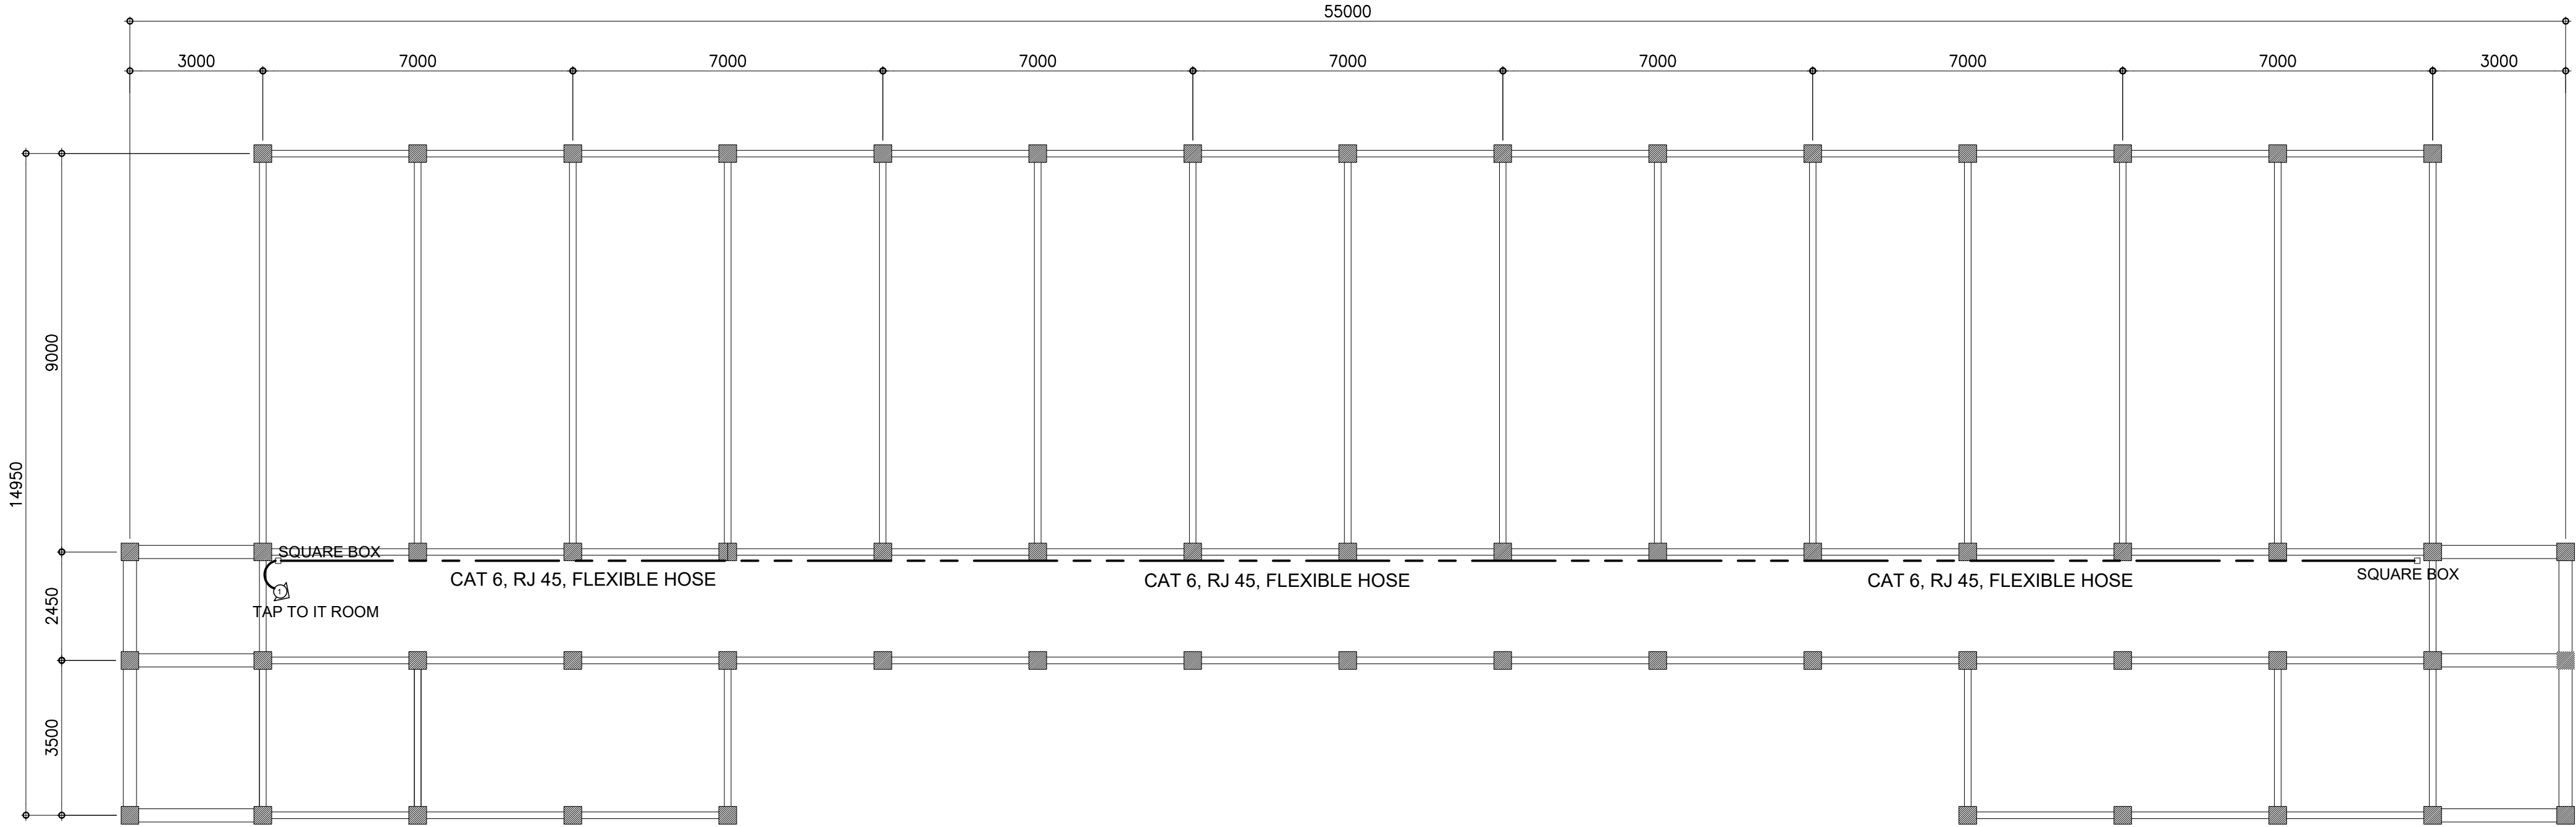

TYPICAL THIRD & FOURTH FLOOR PLAN CCTV LAYOUT PLAN

SCALE : 1:100 M.

LEGEND	DESCRIPTION
	CAT 6, RJ 45, FLEXIBLE HOSE

PROJECT TITLE:

REPAIR & REHABILITATION OF
ACADEMIC BLDG. II AT DINA-
LUPIHAN CAMPUS

LOCATION:

BATAAN PENINSULA STATE UNIVERSITY,
DINALUPIHAN CAMPUS

STRUCTURAL ENGINEER

REG. NO. :
PTR. NO. :
PLACE :
TIN. NO. :

MASTER PLUMBER/SANITARY ENGINEER

REG. NO. :
PTR. NO. :
PLACE :
TIN. NO. :

PROFESSIONAL ELECTRICAL ENGINEER

REG. NO. :
PTR. NO. :
PLACE :
TIN. NO. :

PROFESSIONAL MECHANICAL ENGINEER

REG. NO. :
PTR. NO. :
PLACE :
TIN. NO. :

REVISION

NO.	DESCRIPTION	DATE
1		
2		

PREPARED BY:

AR. ROXETTE S. UMEREZ

ARCHITECT 1, BPSU TWO

REG. NO. :
PTR. NO. :
PLACE :
TIN. NO. :

REVIEWED BY:

MR. BILLY ALPIO

CAMPUS DIRECTOR

NOTED BY:

ENGR. ALFREDO D. VALENTOS

DIRECTOR OF PPES

RECOMMENDED BY:

DR. EDMUNDO C. TUNGOL

VICE PRESIDENT ADMIN. & FINANCE

APPROVED BY:

DR. GREGORIO J. RODIS

UNIVERSITY PRESIDENT

REPUBLIC ACT 9266:

NOTE: THIS DRAWING, AS AN INSTRUMENT OF SERVICE
IS THE PROPERTY OF : BATAAN PENINSULA STATE
UNIVERSITY AND AS SUCH MUST NOT BE
REPRODUCED OR COPIED IN PART OR IN WHOLE
WITHOUT THEIR PERMISSION ALL DRAWINGS ARE
TO BE RETURNED WHEN NO LONGER IN USE.

SHEET CONTENT:

TYPICAL THIRD & FOURTH
CCTV LAYOUT PLAN
LEGEND

SHEET NUMBER

CCTV-DC-01