



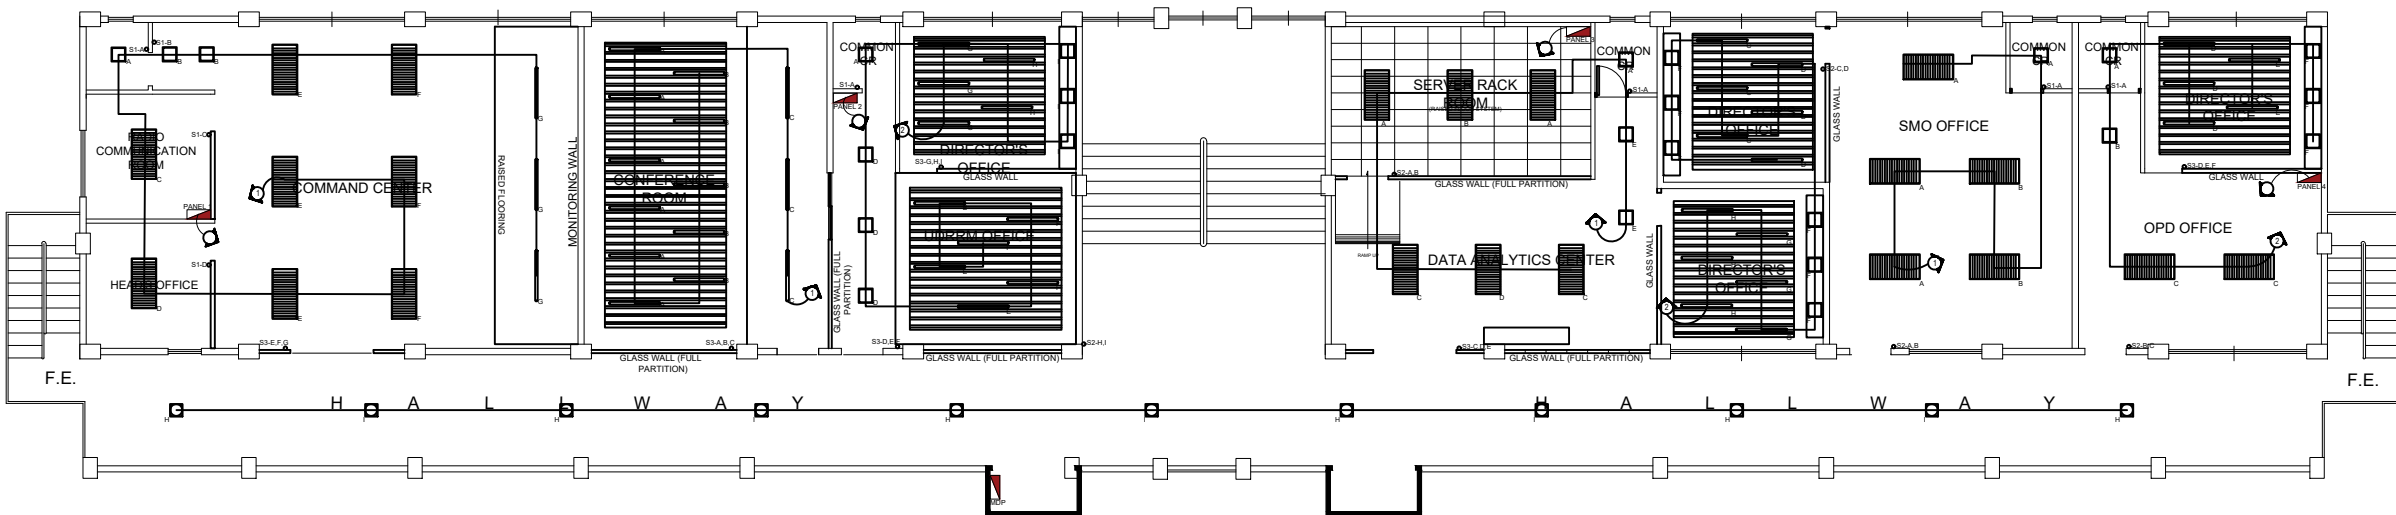

(THIRD FLOOR PLAN)
LIGHTING LAYOUT
SCALE : 1:100 MTS

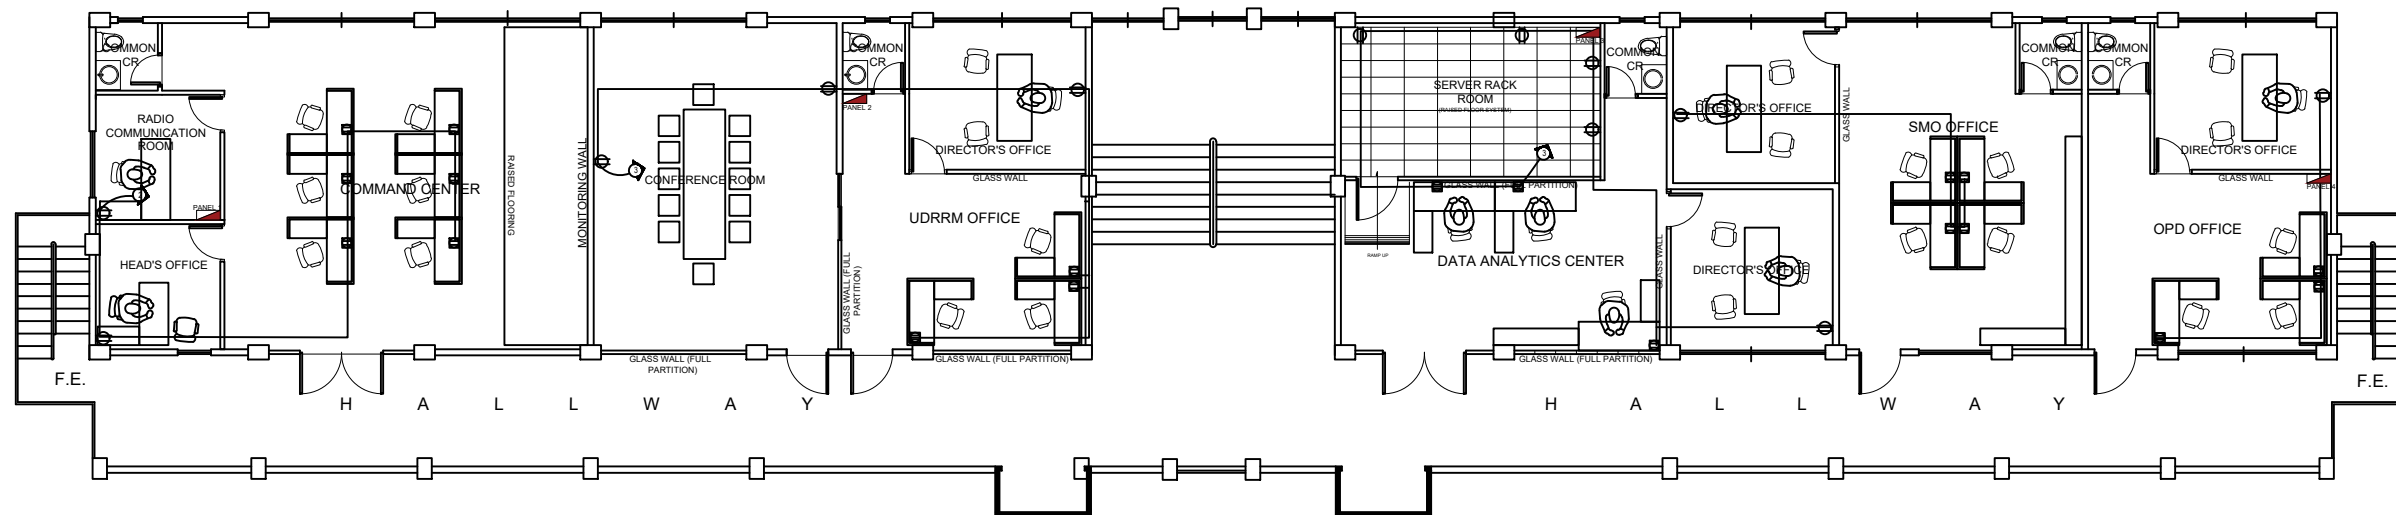

(THIRD FLOOR PLAN)
POWER LAYOUT
SCALE : 1:100 MTS

PROJECT TITLE:
CONVERSION OF ESF THIRD FLOOR BUILDING INTO BPSU COMMAND CENTER AT BPSU MAIN CAMPUS

LOCATION:
BATAAN PENINSULA STATE UNIVERSITY
MAIN CAMPUS

STRUCTURAL ENGINEER
RES. NO. :
PTR. NO. :
PLACE :
TN. NO. :

MASTER PLUMBER/SANITARY ENGINEER
RES. NO. :
PTR. NO. :
PLACE :
TN. NO. :

PROFESSIONAL ELECTRICAL ENGINEER
RES. NO. :
PTR. NO. :
PLACE :
TN. NO. :

PROFESSIONAL MECHANICAL ENGINEER
RES. NO. :
PTR. NO. :
PLACE :
TN. NO. :

REVISION
NO. DESCRIPTION DATE
2

PREPARED BY:
AR. ROXETTE S. UMEREZ
ARCHITECT 1, BPSU TWG HEAD FOR INFRASTRUCTURE

REVIEWED BY:
JASON ANTHONY B. BANZON
CAMPUS DIRECTOR

NOTED BY:
ENGR. ALFREDO D. VALENTOS
DIRECTOR, PPES

RECOMMENDED BY:
DR. EDMUNDO C. TUNGOL
VICE PRESIDENT ADMIN. & FINANCE

APPROVED BY:
DR. GREGORIO J. RODIS
UNIVERSITY PRESIDENT

REPUBLIC ACT 9266.
NOTE: THIS DRAWING, AS AN INSTRUMENT OF SERVICE, IS THE PROPERTY OF : BATAAN PENINSULA STATE UNIVERSITY AND AS SUCH MUST NOT BE REPRODUCED OR COPIED IN PART OR IN WHOLE WITHOUT THEIR PERMISSION. ALL DRAWINGS ARE TO BE RETURNED WHEN NO LONGER IN USE.

SHEET CONTENT: SHEET NUMBER:
• LIGHTING LAYOUT
• POWER LAYOUT
E-MC-01



BATAAN PENINSULA STATE UNIVERSITY
TECHNICAL WORKING GROUP FOR INFRASTRUCTURE
CAPITOL COMPOUND, BPOV, TENGLOKO, CITY OF BALANGA, BATAAN,
E-MAIL: bpsu.techinfo2016@gmail.com / bpsuinfo2017@gmail.com
TELEPHONE NO. : (047) 237-15-08

NOTE : DIMENSIONS ON THESE DRAWINGS SHALL HAVE PRECEDENCE OVER SCALE DIMENSIONS. CONTRACTORS SHALL VERIFY AND BE RESPONSIBLE FOR ALL DIMENSIONS AND CONDITIONS ON THE JOB. THE DESIGNER MUST BE NOTIFIED IMMEDIATELY OF ANY VARIATIONS FROM THE DIMENSIONS AND CONDITIONS SHOWN BY THESE DRAWINGS.